



HAMLET OF TUKTOYAKTUK

DRAWING LIST

SHEET NUMBER	DRAWING NAME
C-0000	COVER SHEET
C-1000	OVERALL PLAN - INDEX AND TOPOGRAPHY
C-1001	SITE PLAN
C-1100	PLAN AND PROFILE - DYKE - STATION 1+000 TO 1+200
C-1101	PLAN AND PROFILE - TEMPORARY TRUCK DUMP ACCESS FUTURE RV DUMP STATION ACCESS
C-3000	SECTIONS (SHEET 1 OF 2)
C-3001	SECTIONS (SHEET 2 OF 2)
C-4000	DETAILS

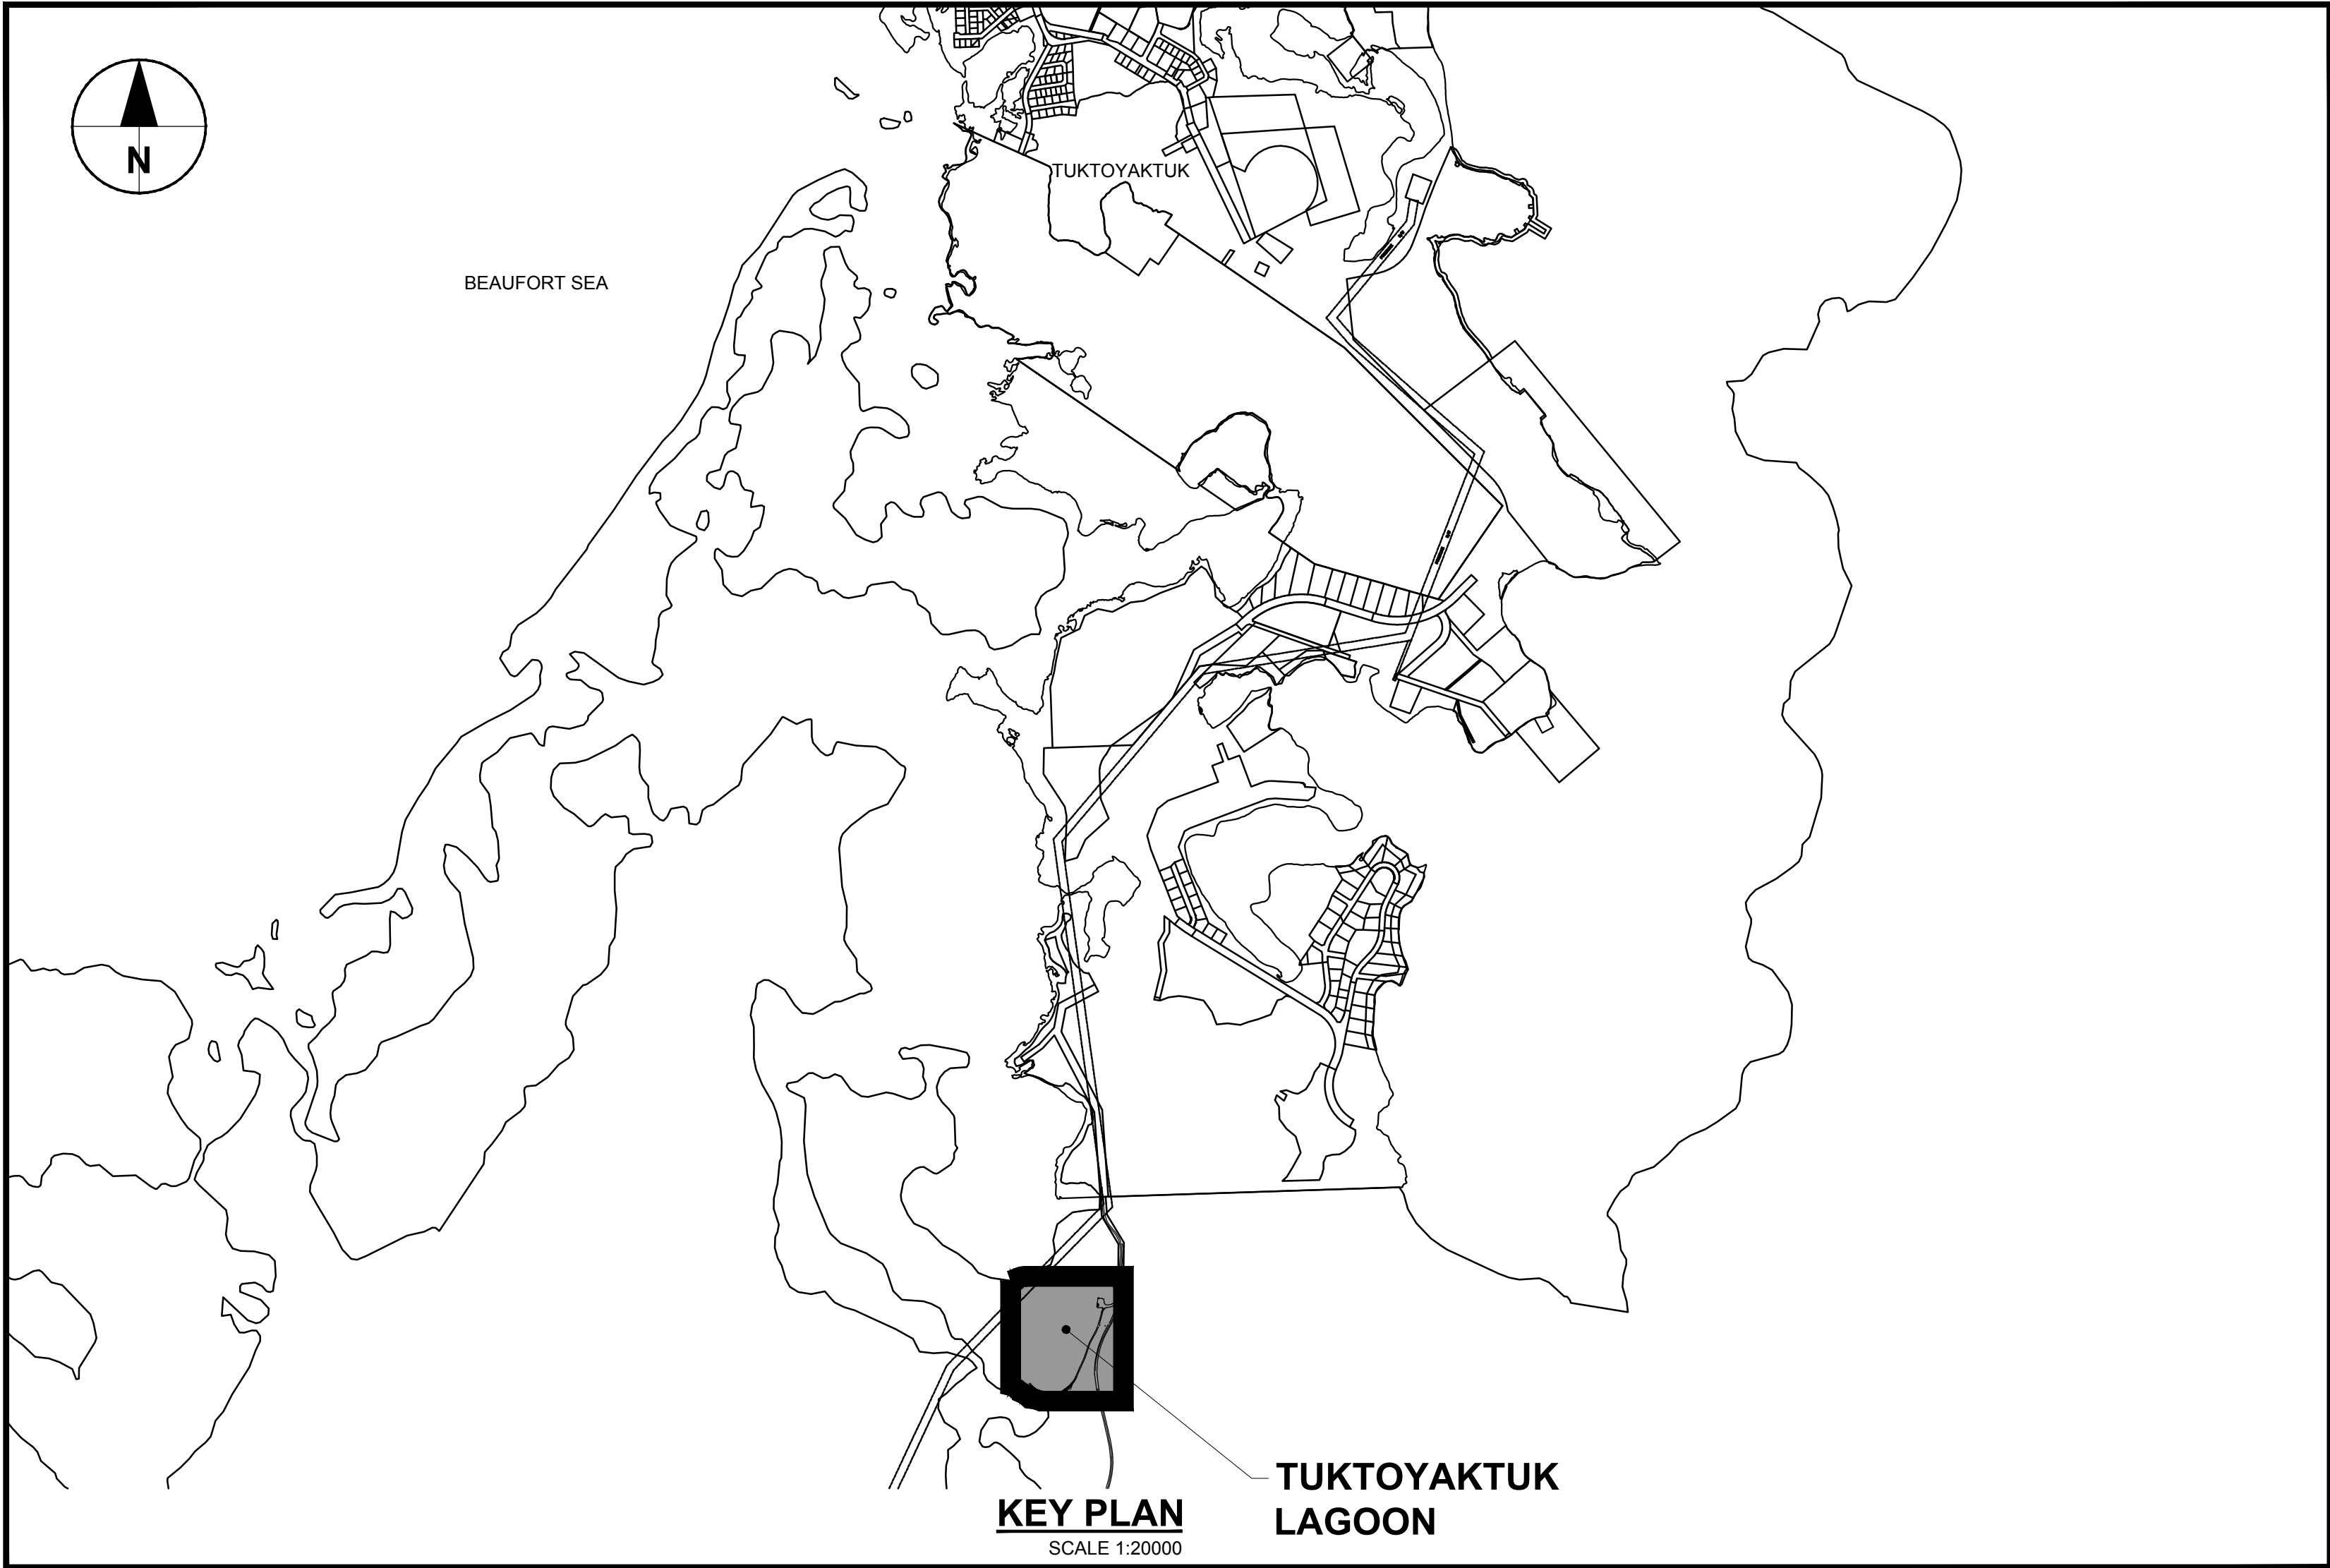

HAMLET OF TUKTOYAKTUK SEWAGE LAGOON UPGRADES

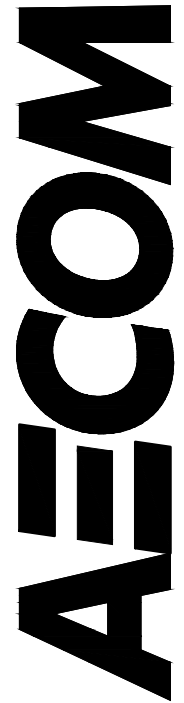

2017-01-24
INUVIALUIT WATER BOARD REVIEW

60519663



- GENERAL NOTES:**
1. ALL DIMENSIONS AND ELEVATIONS ARE IN METRES UNLESS NOTED OTHERWISE.
 2. CONTOURS DERIVED FROM DEC 2016 SURVEY AND ARE SHOWN IN 0.5 m INTERVALS.

AECOM

PROJECT

**TUKTOYAKTUK
SEWAGE LAGOON
UPGRADES**

CLIENT

**HAMLET OF
TUKTOYAKTUK**

CONSULTANT

AECOM
101, 18817 - STONY PLAIN ROAD NW
EDMONTON AB T5S 0C2
780.486.7000 tel 780.486.7070 fax
www.aecom.com

REGISTRATION

ISSUE/REVISION		
C	2017-01-24	INUVIALUIT WATER BOARD
B	2017-01-12	ISSUED FOR 95% REVIEW
A	2016-12-21	ISSUED FOR 80% REVIEW
I/R	DATE	DESCRIPTION

KEY PLAN

PROJECT NUMBER

60519663



SHEET TITLE





OVERALL PLAN
INDEX AND TOPOGRAPHY

SHEET NUMBER

C-1000

This drawing has been prepared for the use of AECOM's client and may not be used, reproduced or relied upon by third parties, except as agreed by AECOM and its client, as required by law or for use by governmental reviewing agencies. AECOM accepts no responsibility, and denies any liability whatsoever, to any party that modifies this drawing without AECOM's express written consent. Do not scale this document. All measurements must be obtained from stated dimensions.

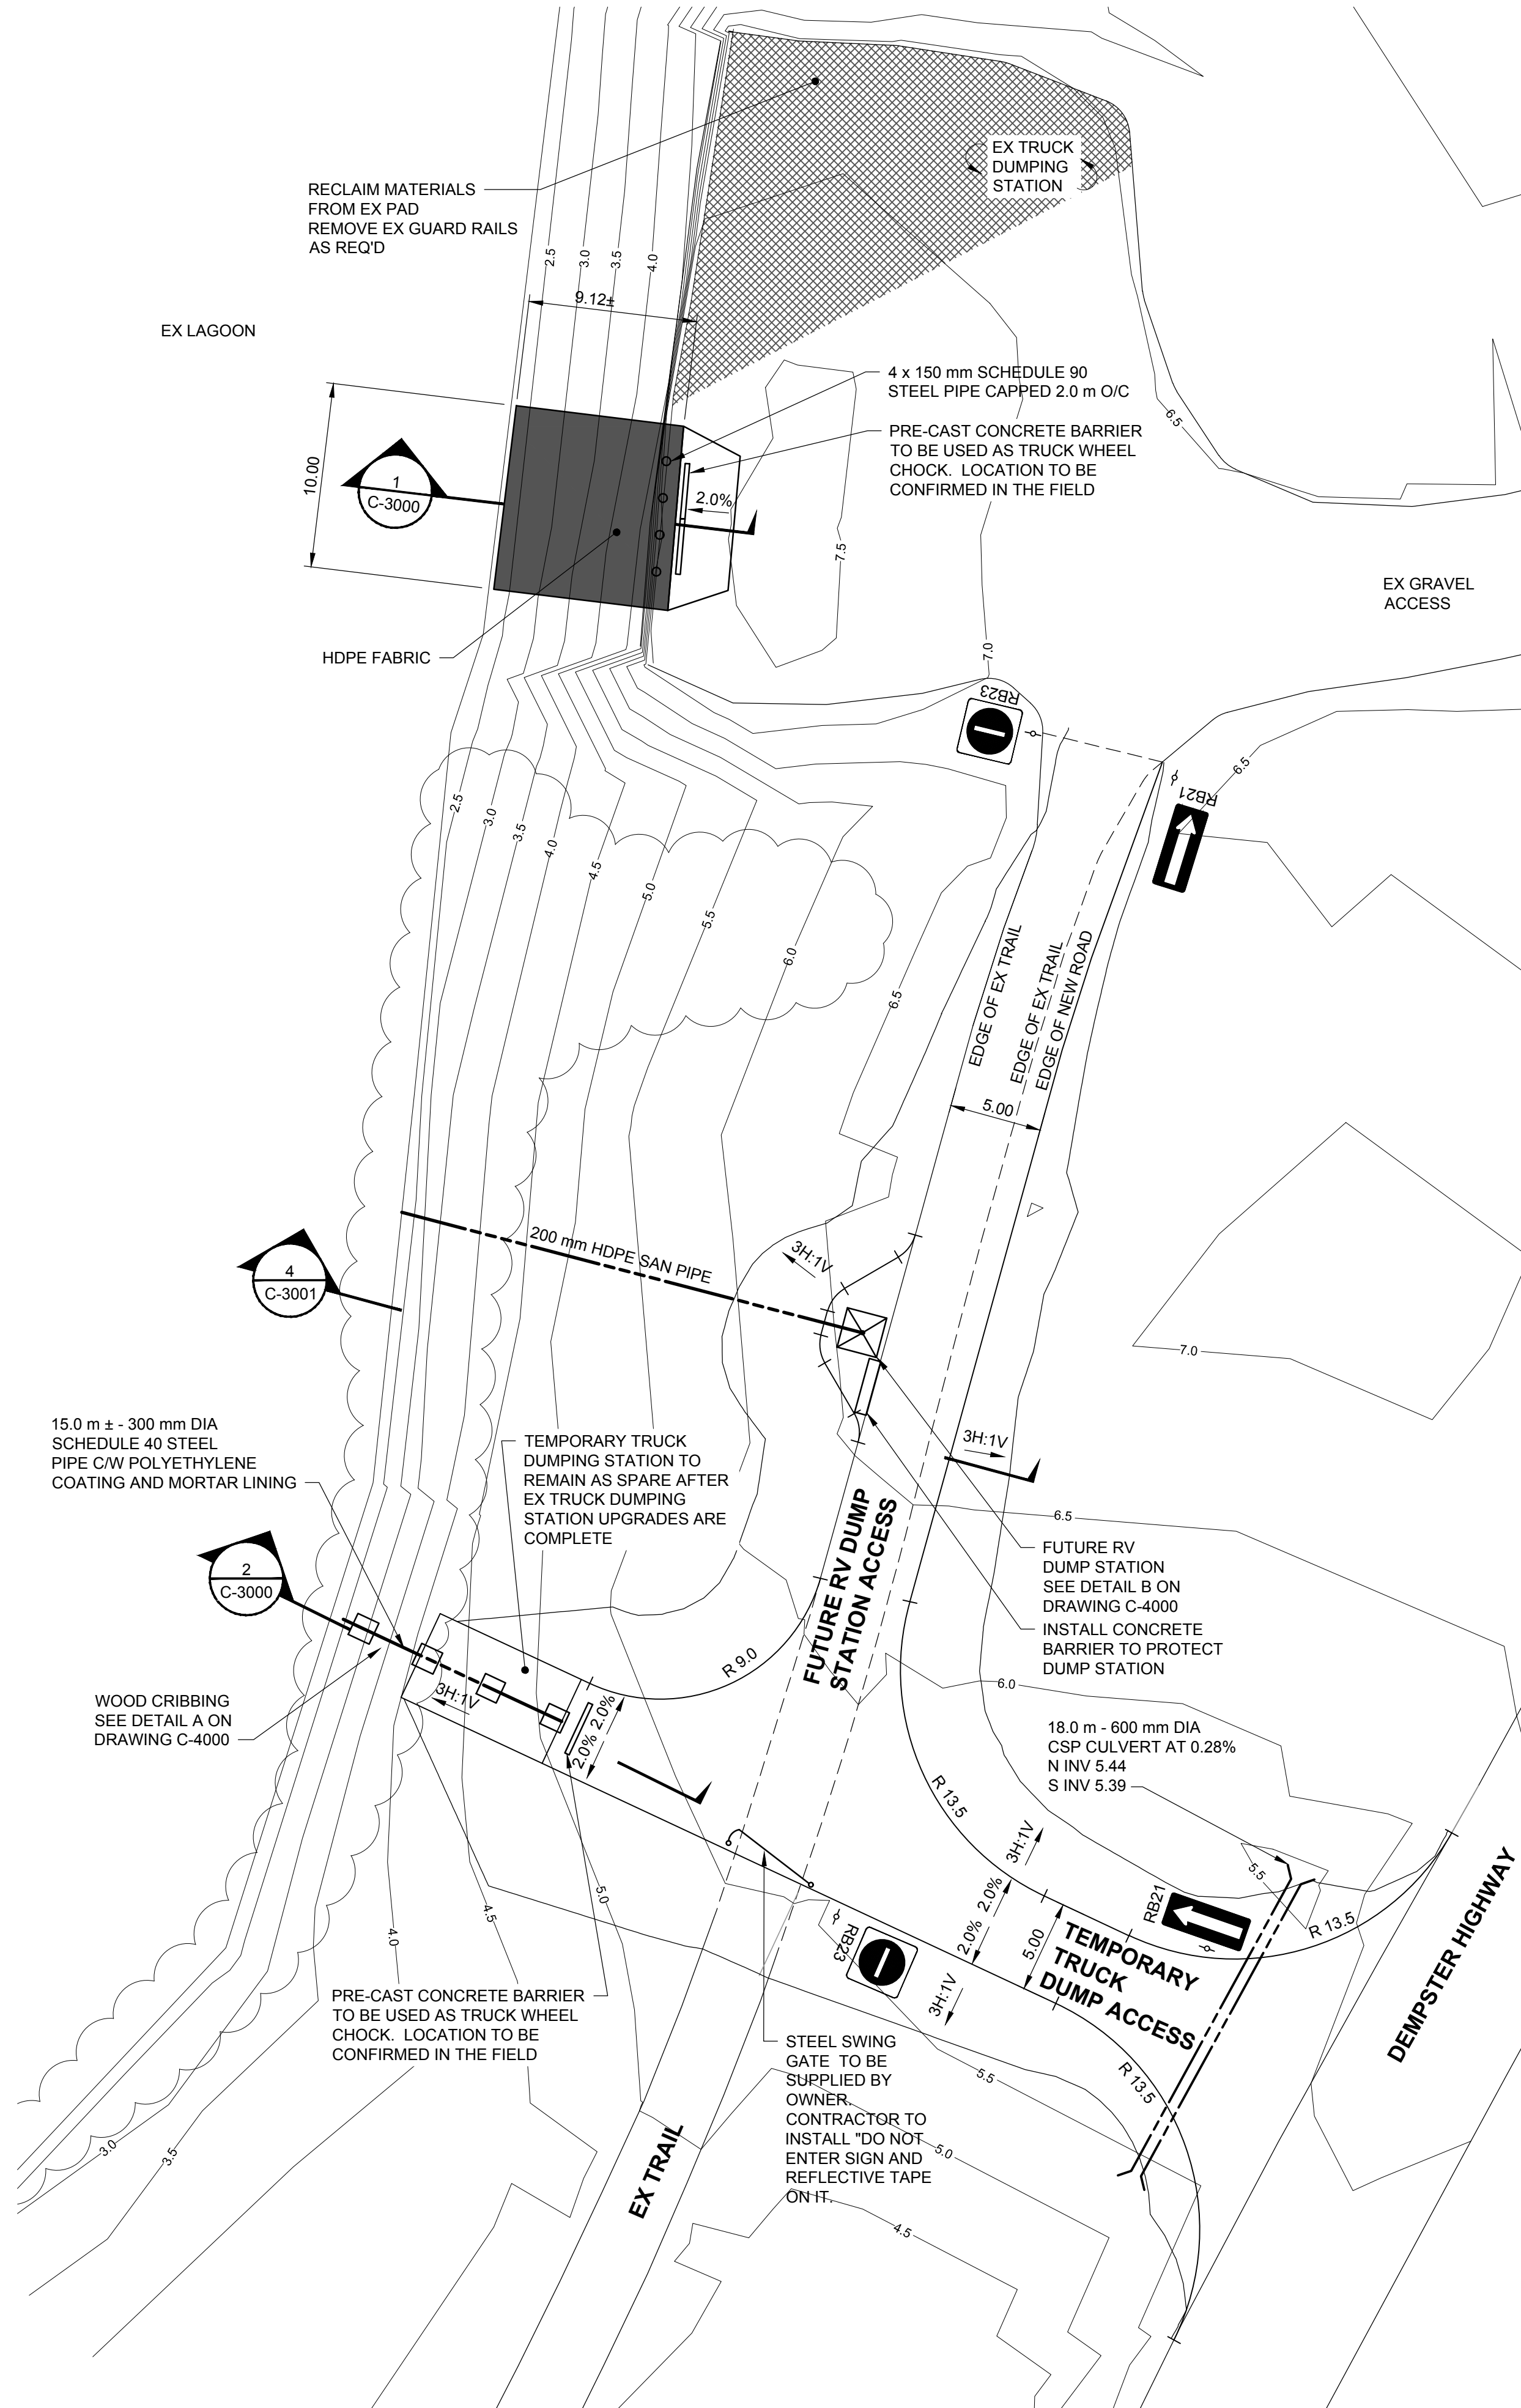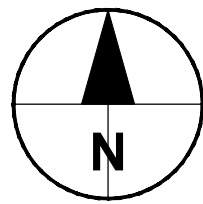

 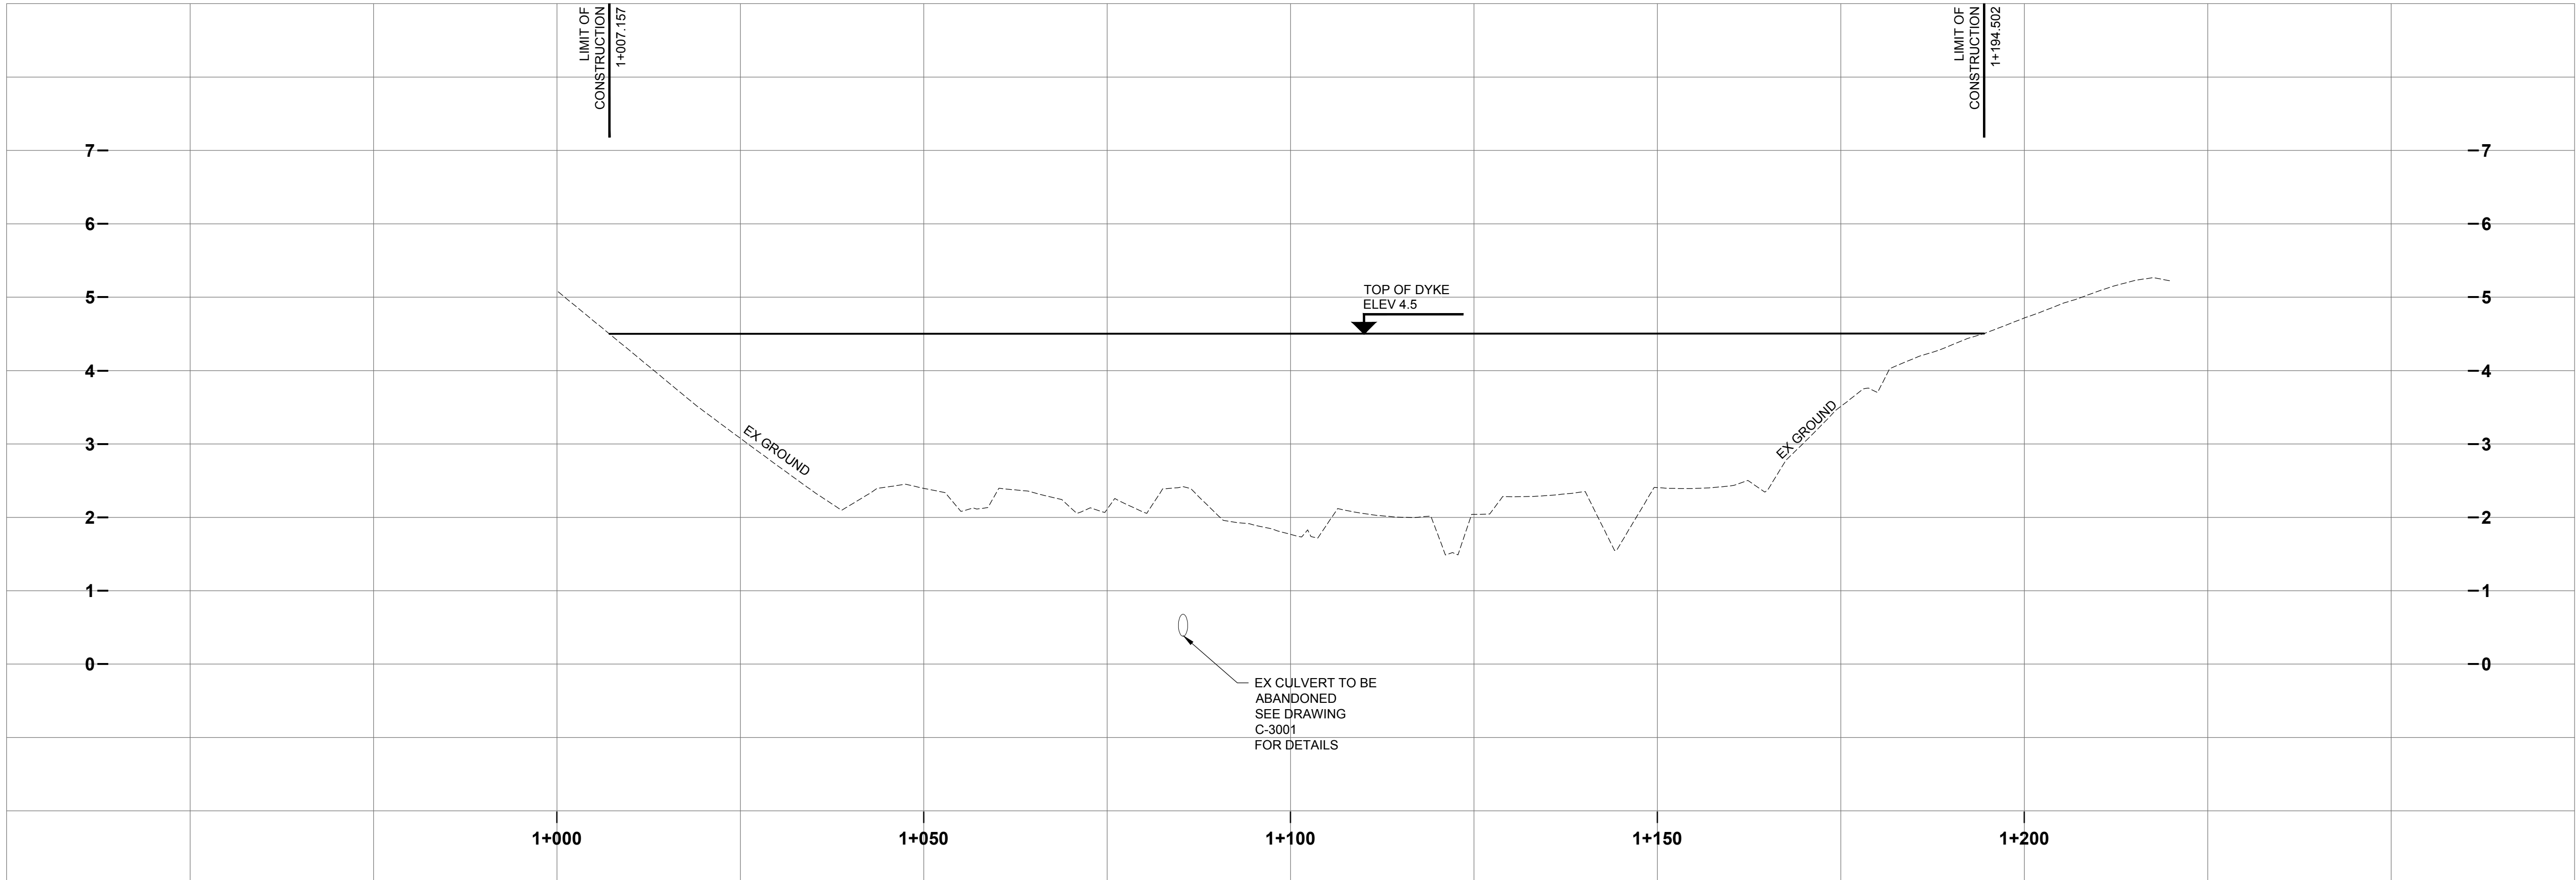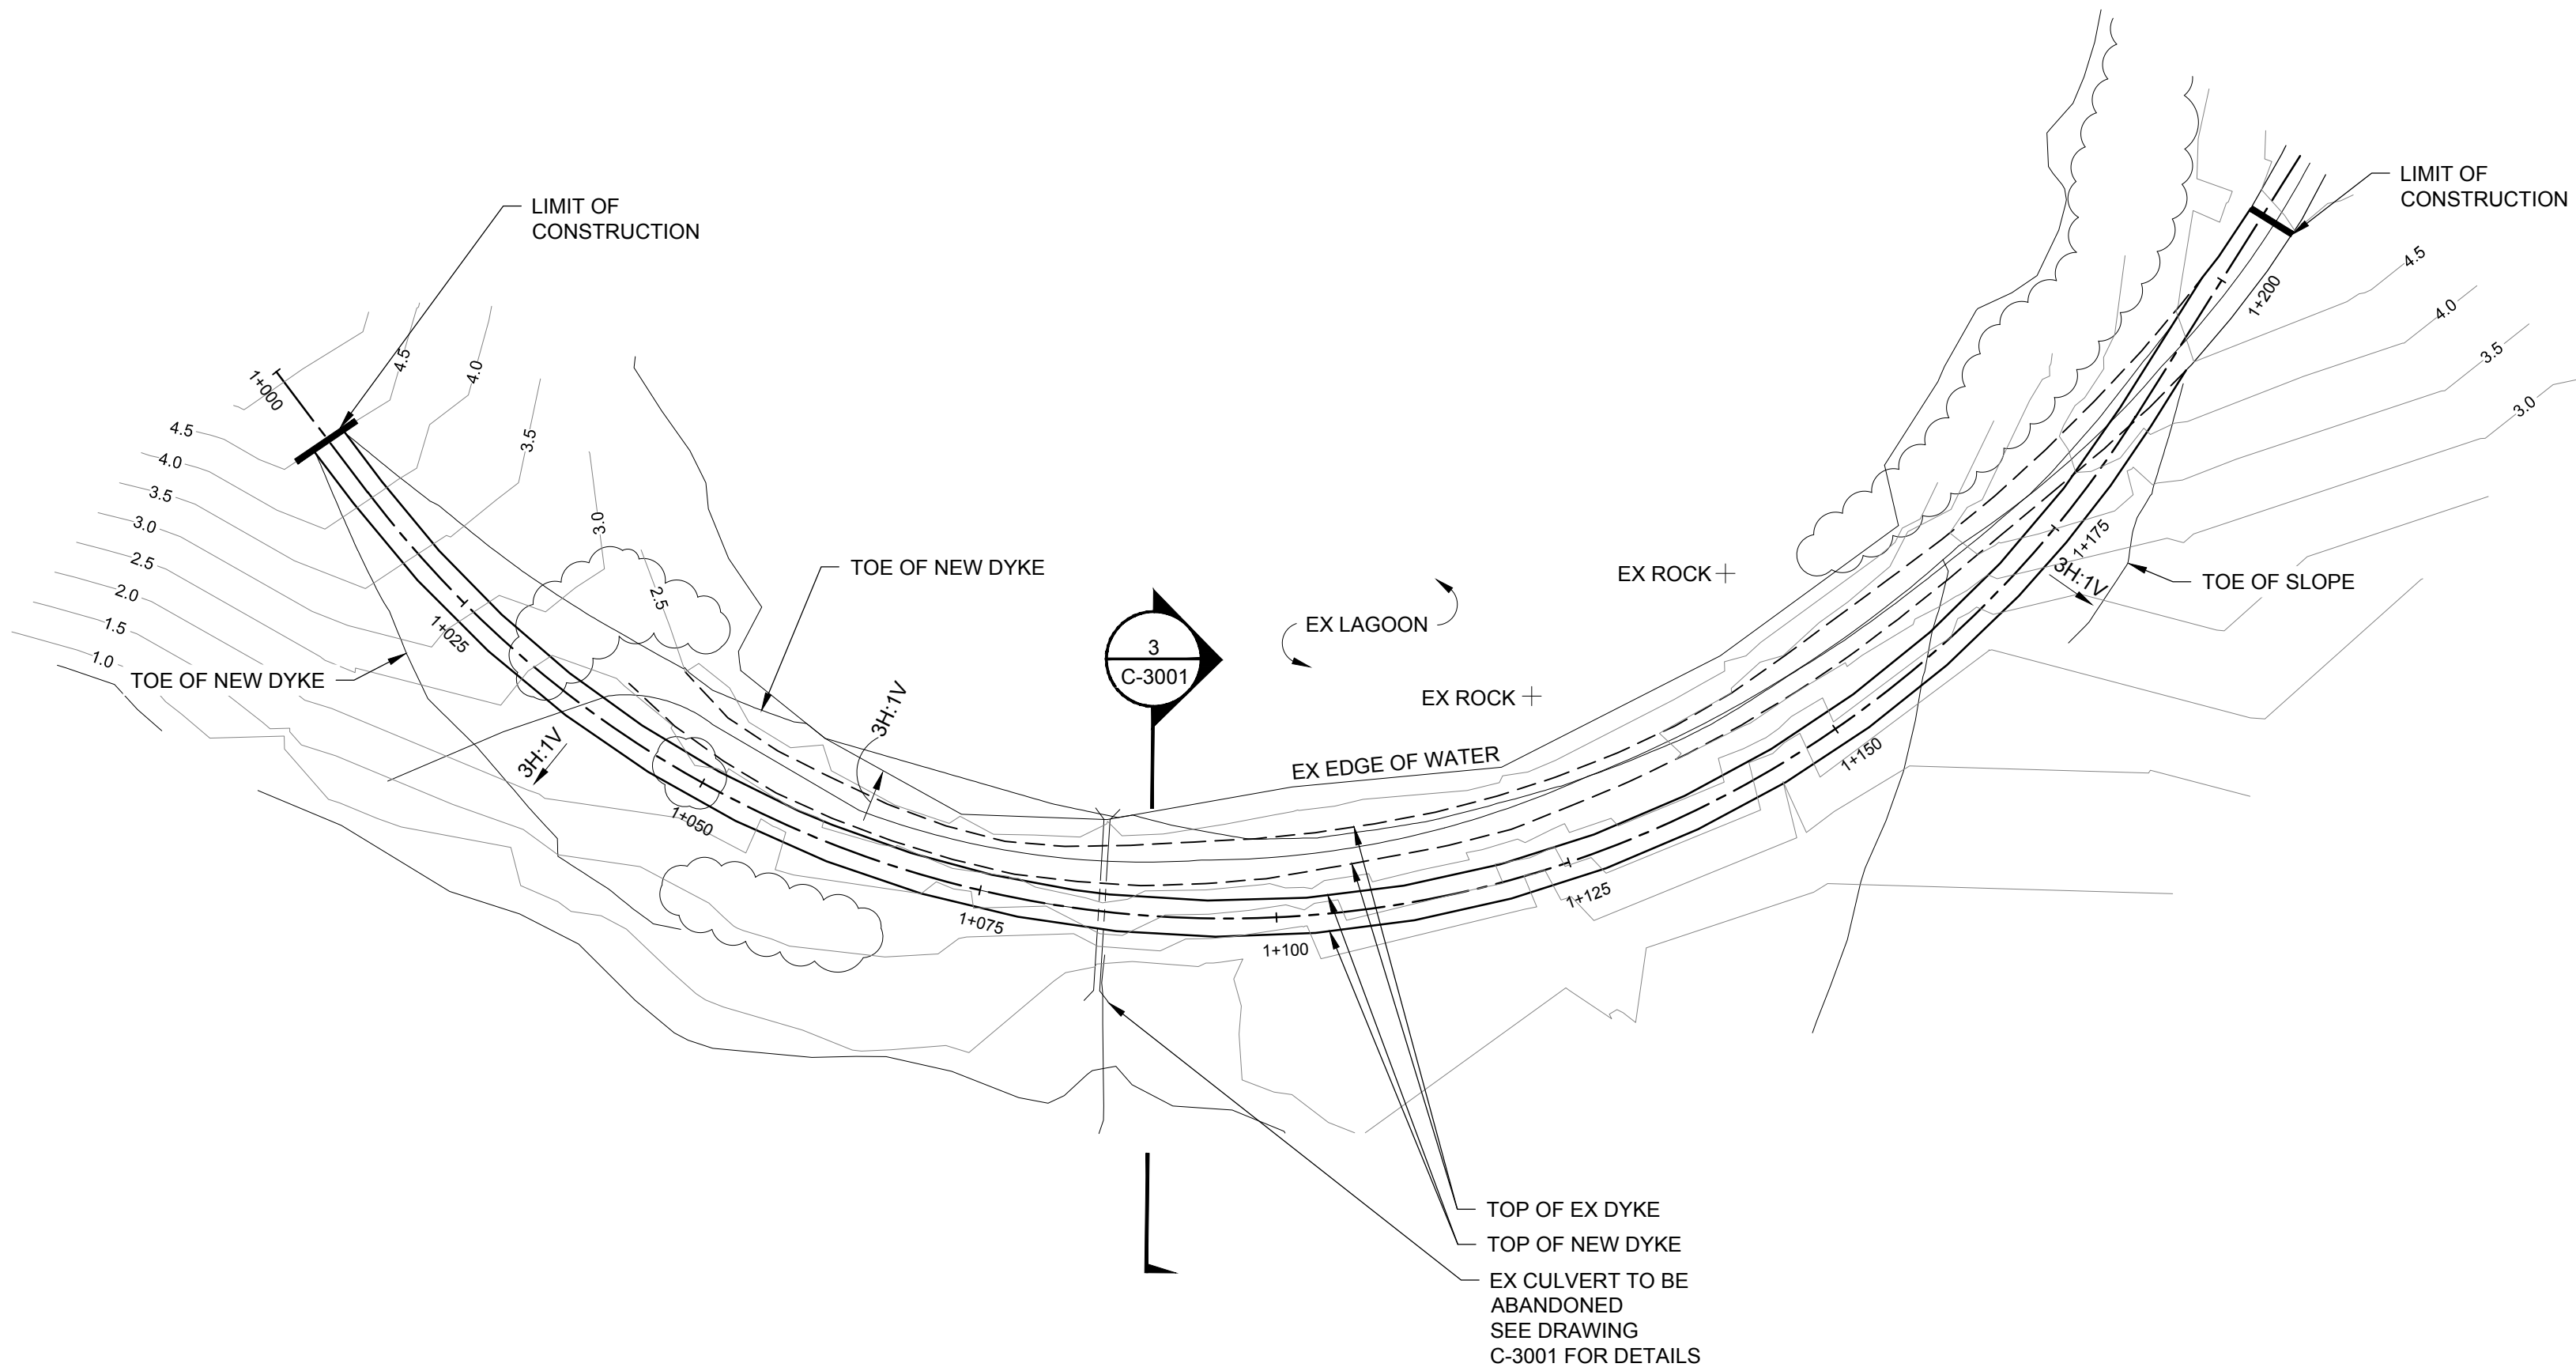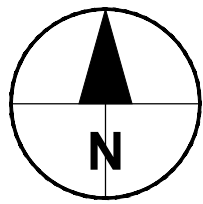

GENERAL NOTES:

1. ALL DIMENSIONS AND ELEVATIONS ARE IN METRES UNLESS NOTED OTHERWISE.
2. CONTOURS DERIVED FROM DEC 2016 SURVEY AND ARE SHOWN IN 0.5 m INTERVALS.

AECOM

PROJECT

**TUKTOYAKTUK
SEWAGE LAGOON
UPGRADES**

CLIENT

**HAMLET OF
TUKTOYAKTUK**

CONSULTANT

AECOM
101, 18817 - STONY PLAIN ROAD NW
EDMONTON AB T5S 0C2
780.486.7000 tel 780.486.7070 fax
www.aecom.com

REGISTRATION

ISSUE/REVISION

I/R	DATE	DESCRIPTION
C	2017-01-24	INUVIALUIT WATER BOARD
B	2017-01-12	ISSUED FOR 95% REVIEW
A	2016-12-21	ISSUED FOR 80% REVIEW

KEY PLAN

PROJECT NUMBER

60519663


SHEET TITLE

PLAN AND PROFILE
DYKE
STATION 1+000 TO 1+200


SHEET NUMBER

C-1100

This drawing has been prepared for the use of AECOM's client and may not be used, reproduced or relied upon by third parties, except as agreed by AECOM and its client, as required by law or for use by governmental reviewing agencies. AECOM accepts no responsibility, and denies any liability whatsoever, to any party that modifies this drawing without AECOM's express written consent. Do not scale this document. All measurements must be obtained from stated dimensions.

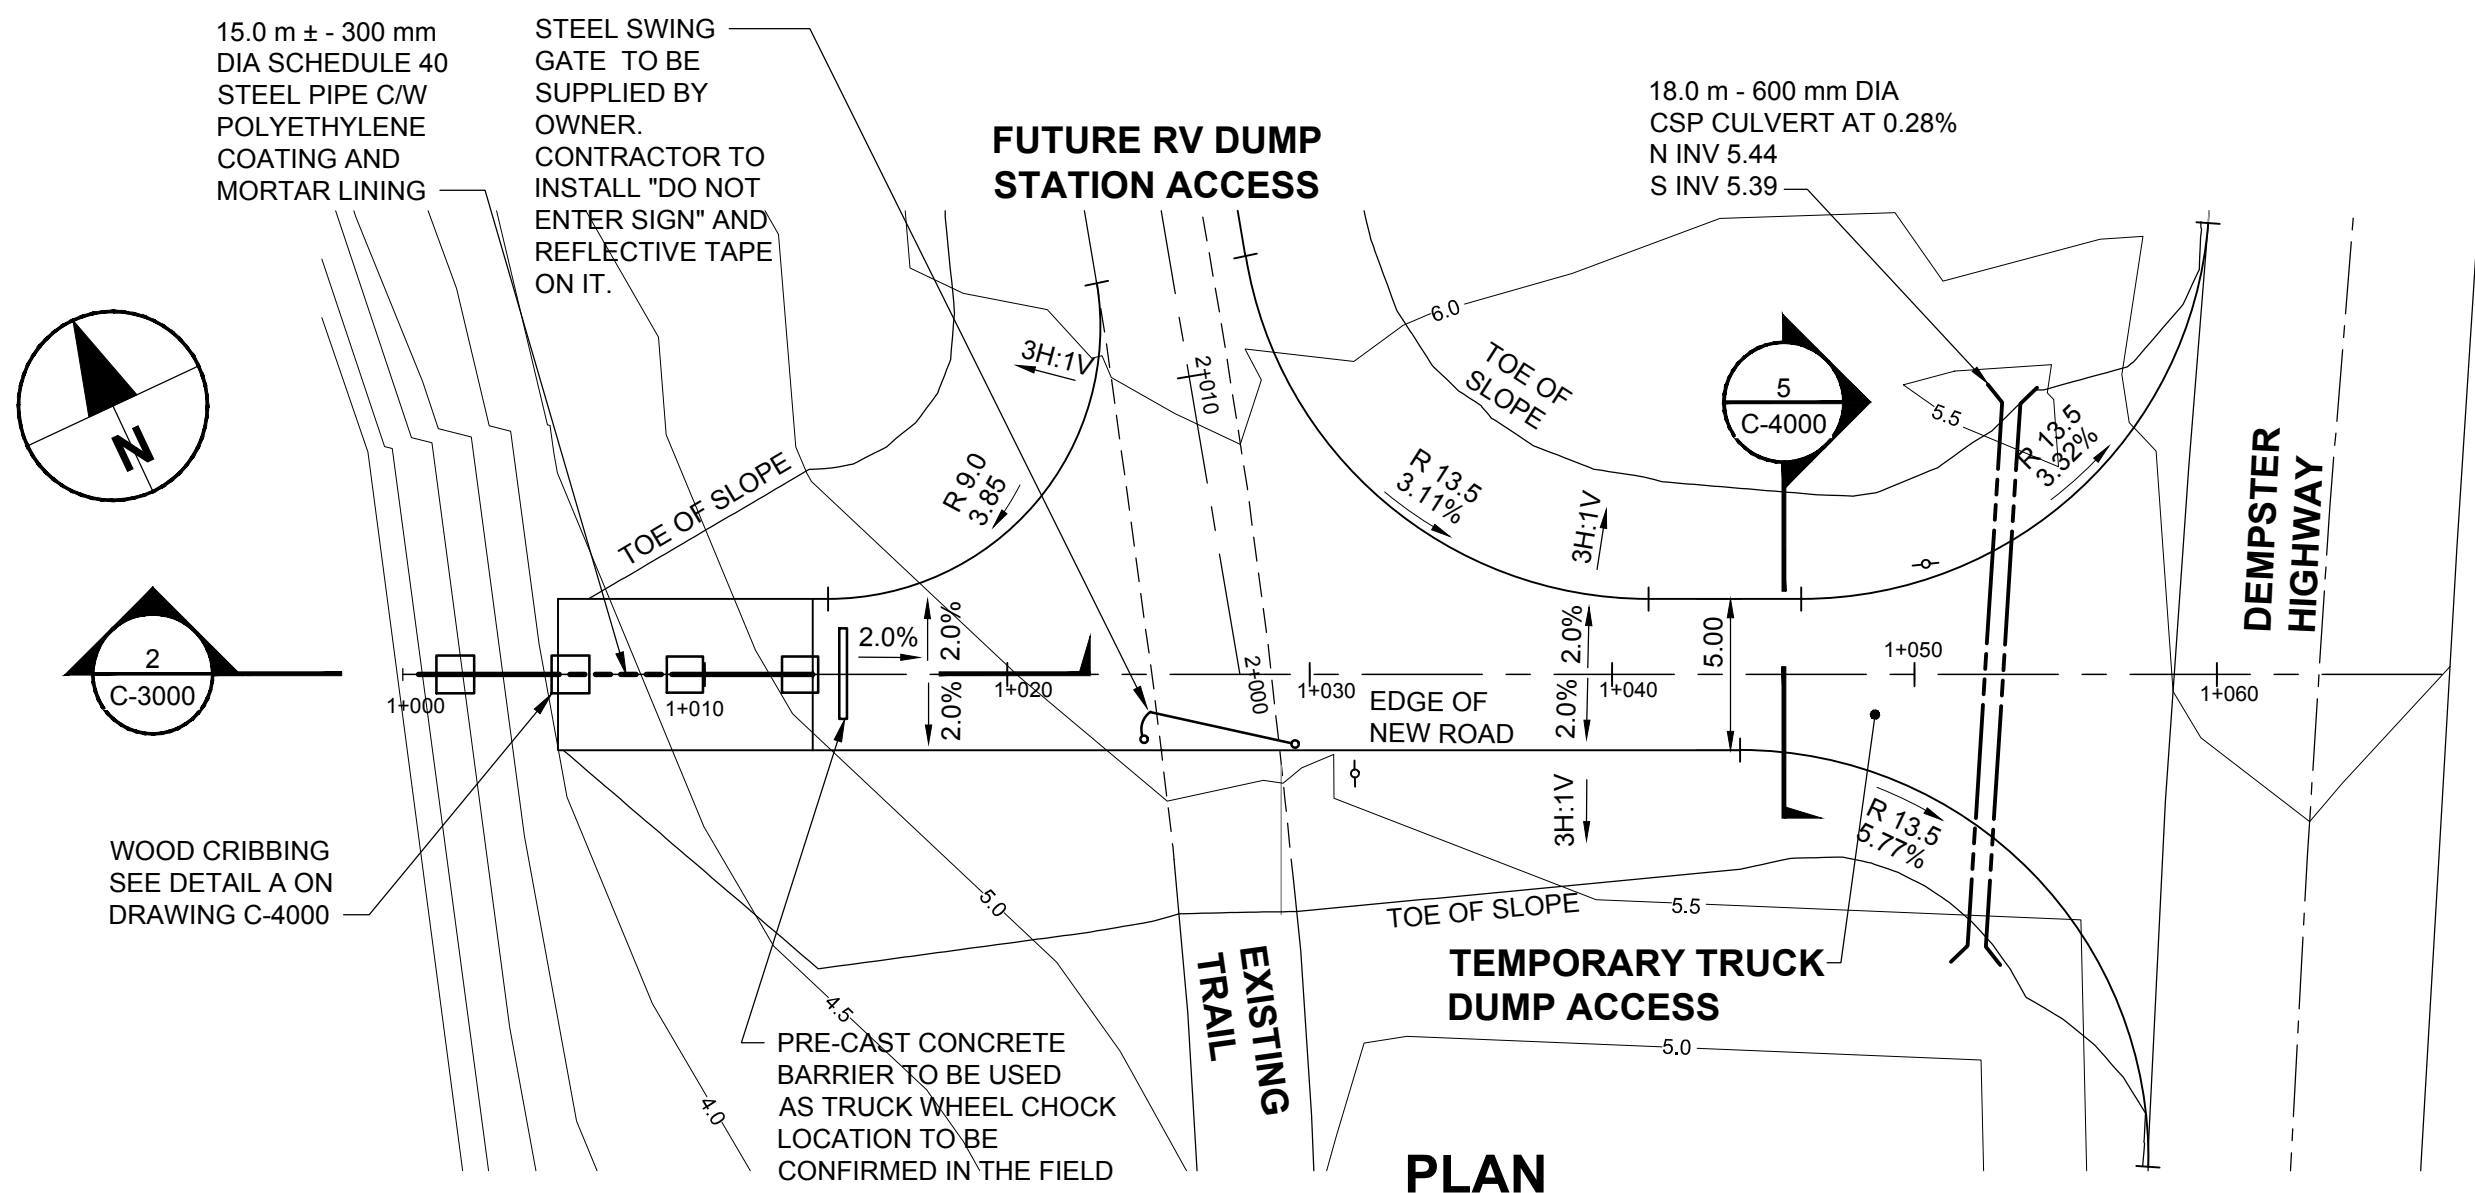


PLAN

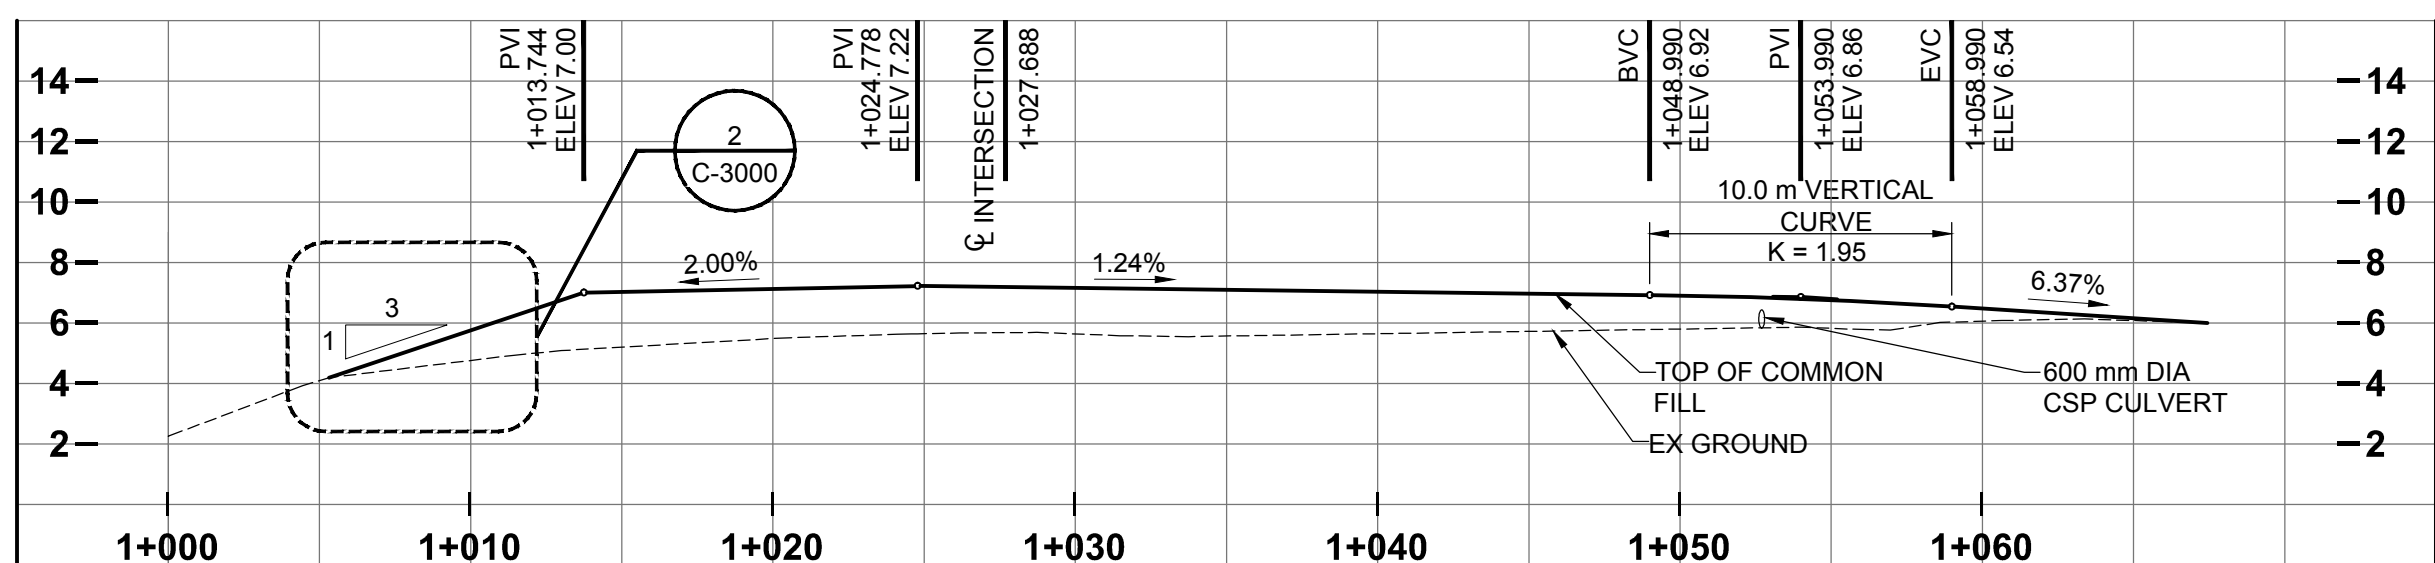


PROFILE

TEMPORARY TRUCK DUMP ACCESS

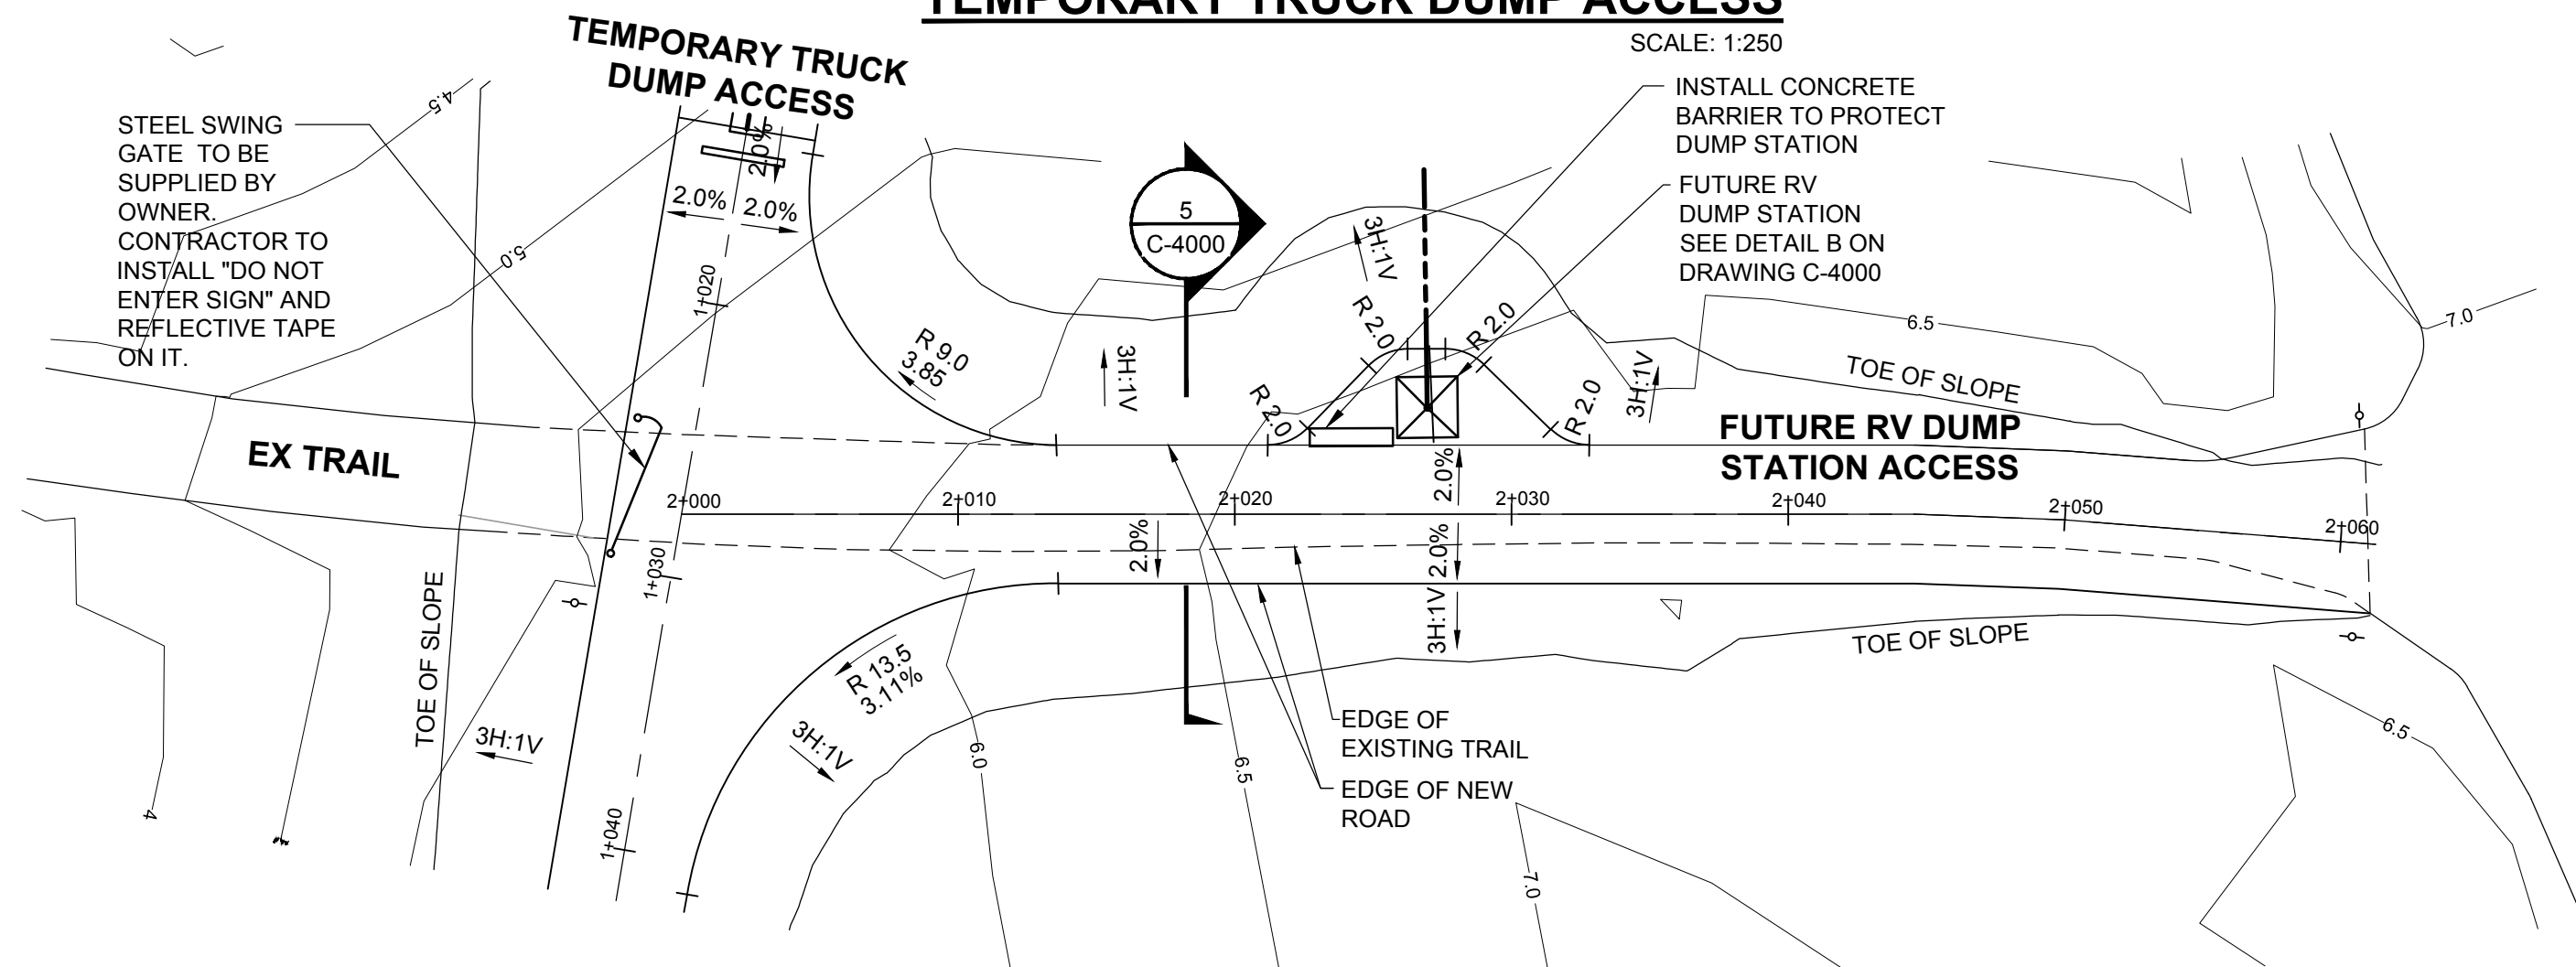

PLAN

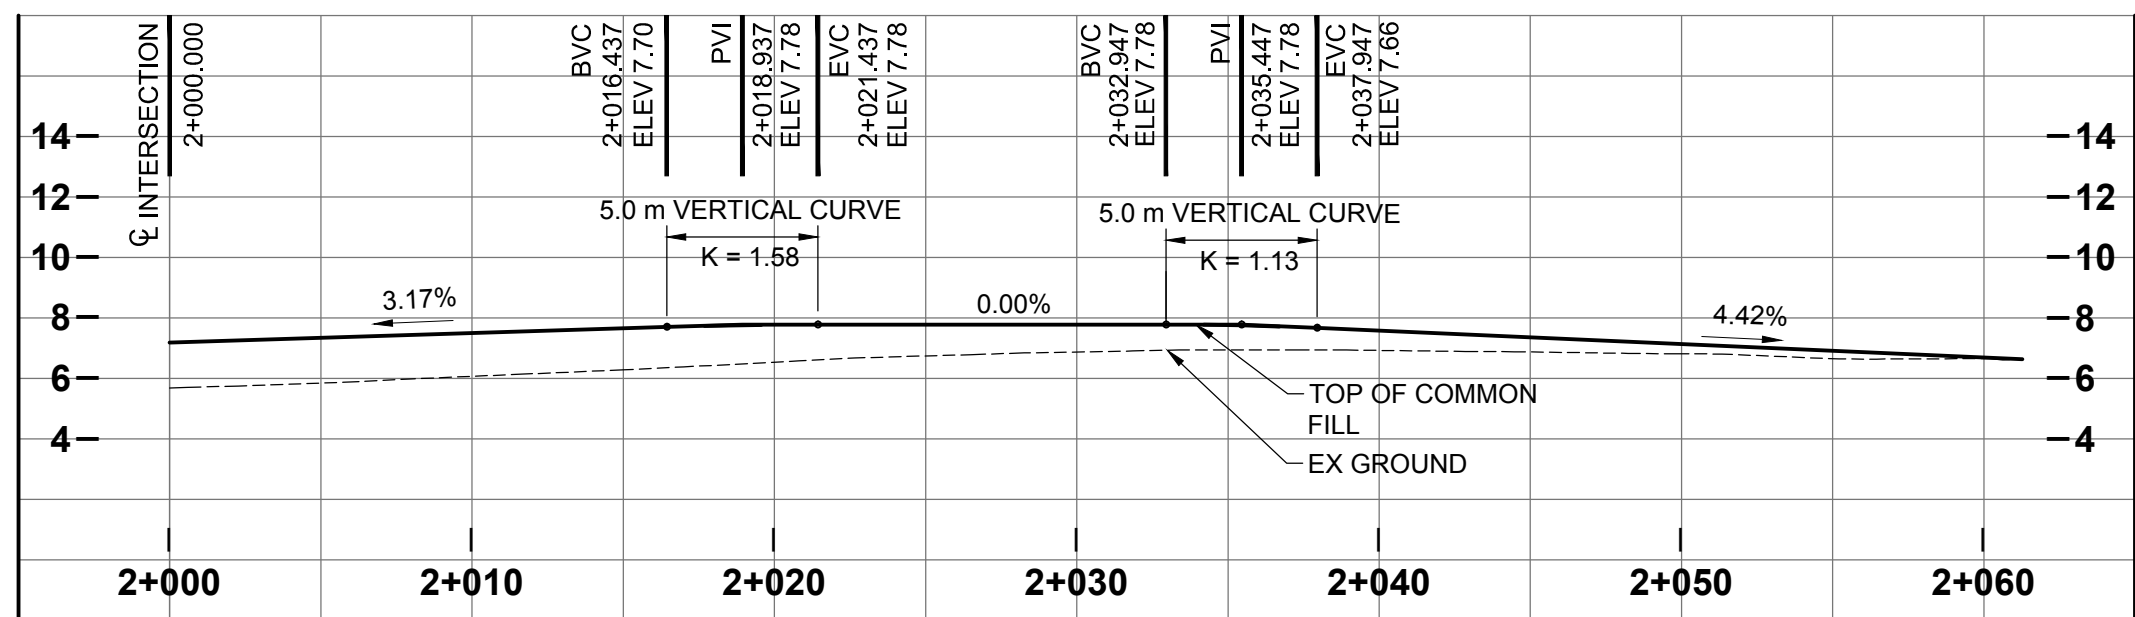

PROFILE

FUTURE RV DUMP STATION ACCESS

SCALE: 1:250

GENERAL NOTES:

1. ALL DIMENSIONS AND ELEVATIONS ARE IN METRES UNLESS NOTED OTHERWISE.
2. CONTOURS DERIVED FROM DEC 2016 SURVEY AND ARE SHOWN IN 0.5 m INTERVALS

AECOM

PROJECT

TUKTOYAKTUK SEWAGE LAGOON UPGRADES

CLIENT

HAMLET OF TUKTOYAKTUK

CONSULTANT

AECOM
101, 18817 - STONY PLAIN ROAD NW
EDMONTON AB T5S 0C2
780.486.7000 tel 780.486.7070 fax
www.aecom.com

REGISTRATION

ISSUE/REVISION		
C	2017-01-24	INUVALUIT WATER BOARD
B	2017-01-12	ISSUED FOR 95% REVIEW
A	2016-12-21	ISSUED FOR 80% REVIEW
I/R	DATE	DESCRIPTION

KEY PLAN

PROJECT NUMBER



60519663

SHEET TITLE

PLAN AND PROFILE
TEMPORARY TRUCK DUMP ACCESS
FUTURE RV DUMP STATION ACCESS

SHEET NUMBER

C-1101

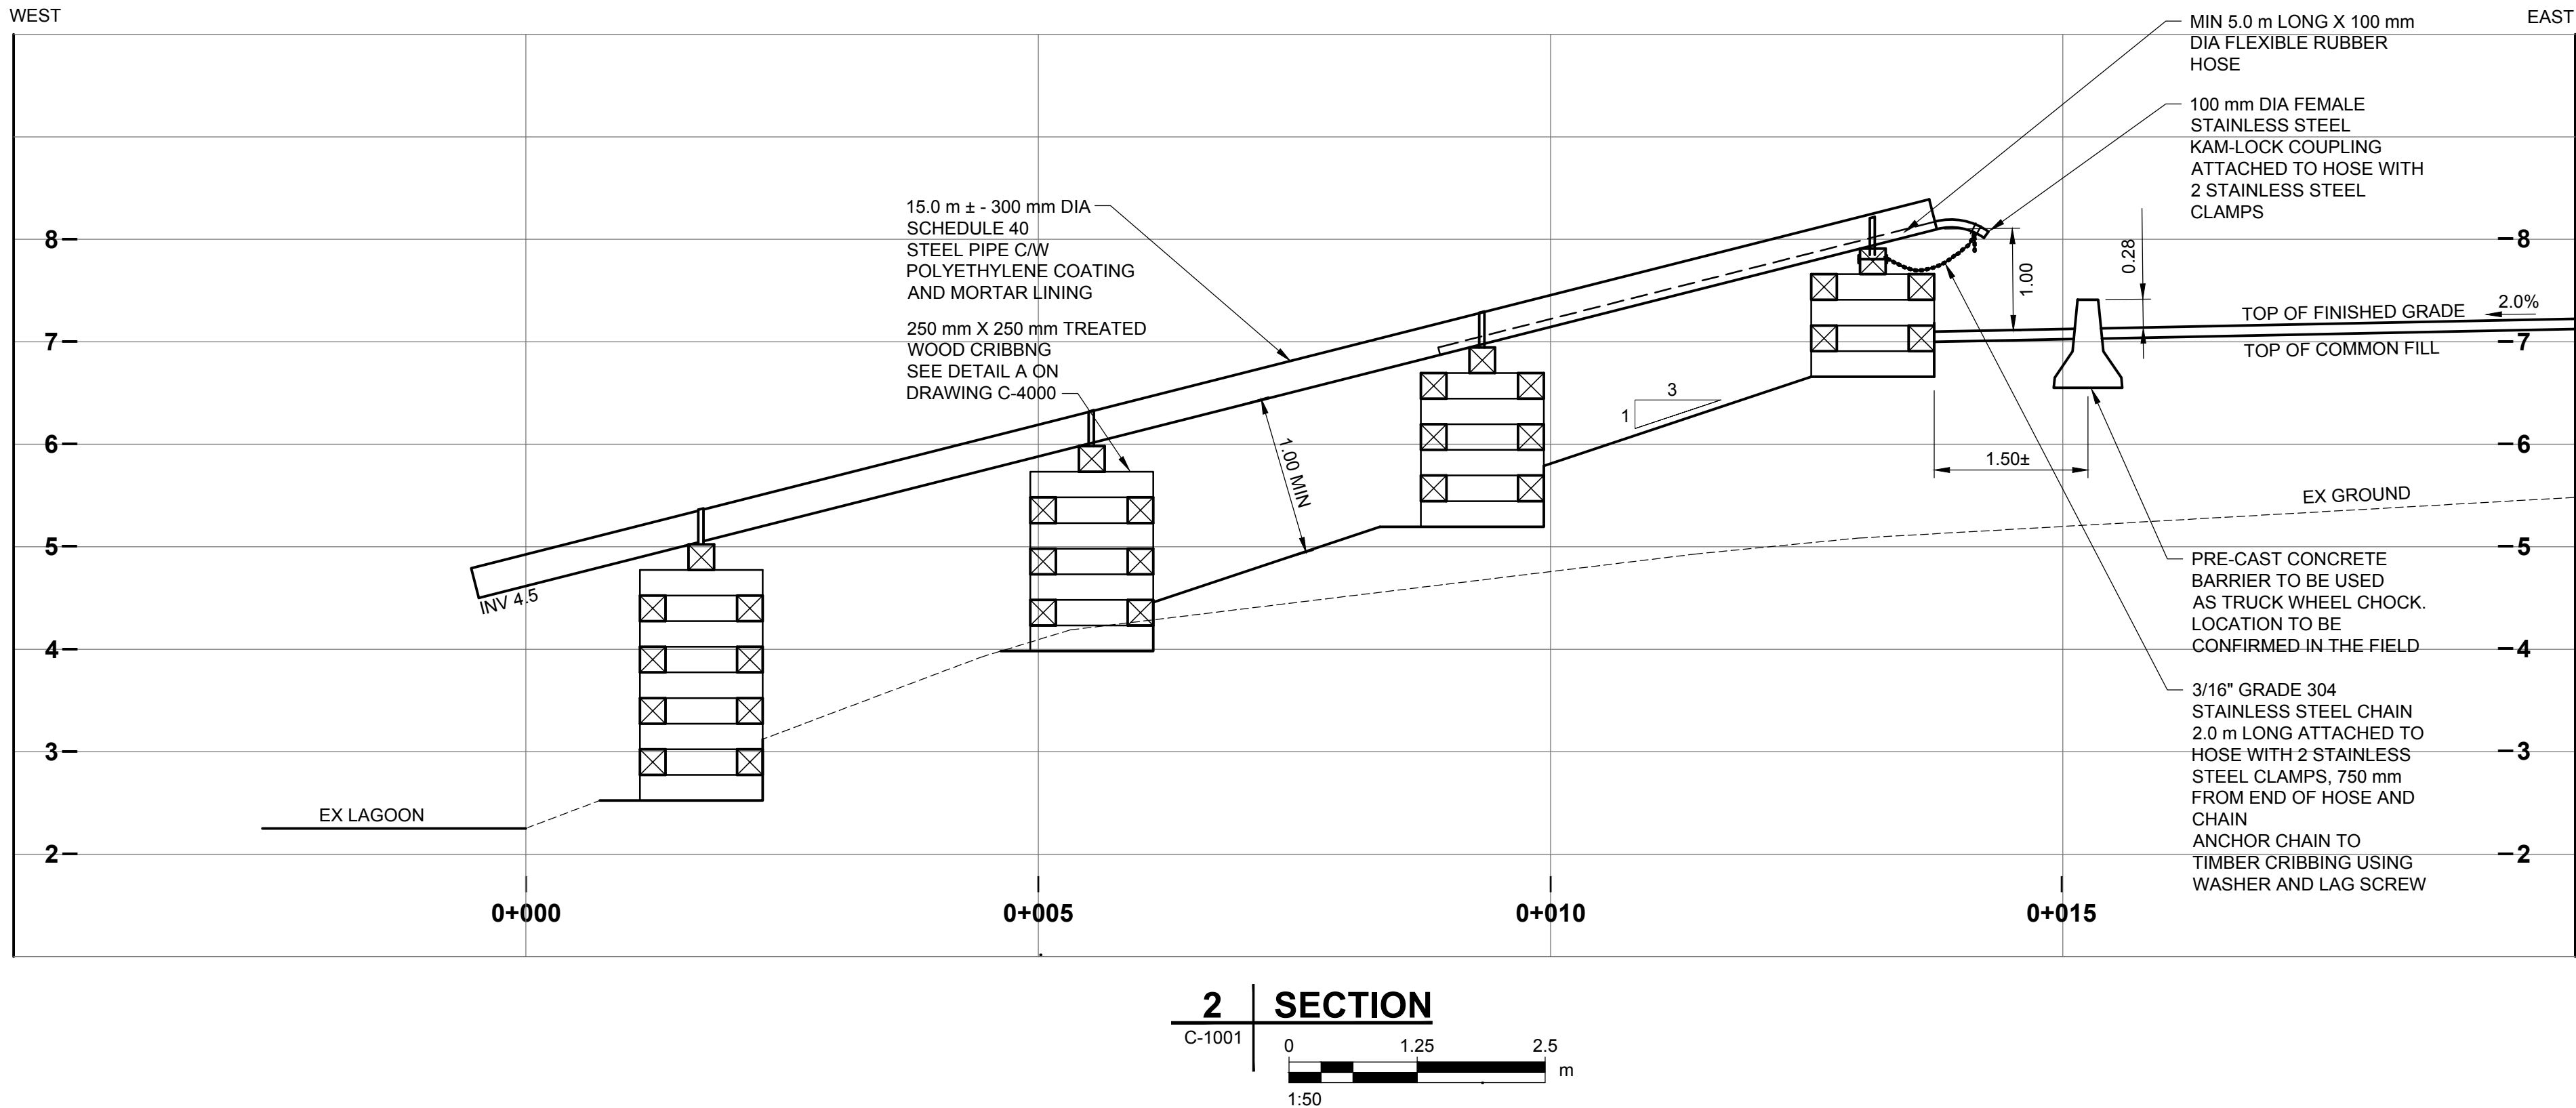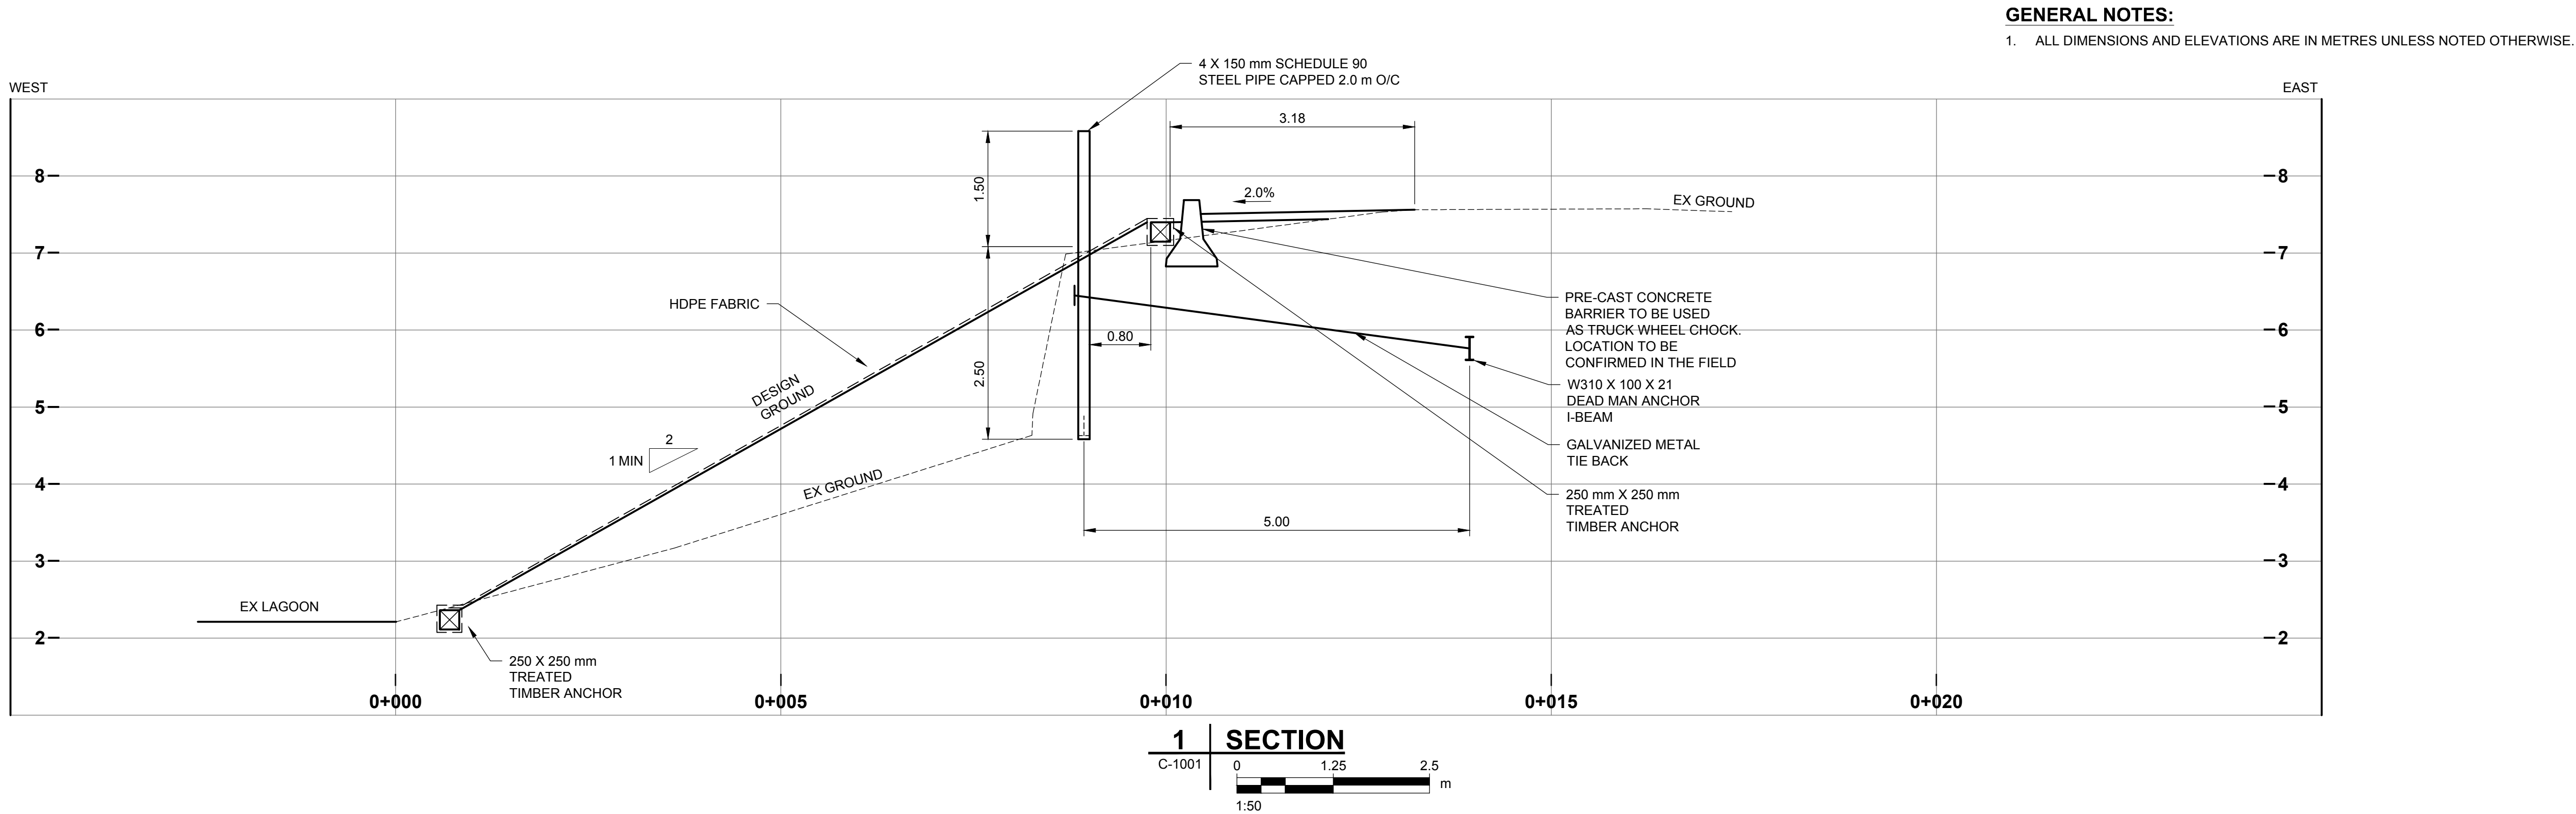

AECOM

PROJECT

TUKTOYAKTUK
SEWAGE LAGOON
UPGRADES

CLIENT

HAMLET OF
TUKTOYAKTUK

CONSULTANT

AECOM
101, 18817 - STONY PLAIN ROAD NW
EDMONTON AB T5S 0C2
780.486.7000 tel 780.486.7070 fax
www.aecom.com

REGISTRATION

ISSUE/REVISION

I/R	DATE	DESCRIPTION
C	2017-01-24	INUUVIUIT WATER BOARD
B	2017-01-12	ISSUED FOR 95% REVIEW
A	2016-12-21	ISSUED FOR 80% REVIEW

KEY PLAN

PROJECT NUMBER

60519663


SHEET TITLE

SECTIONS
(SHEET 1 OF 2)


SHEET NUMBER

C-3000

This drawing has been prepared for the use of AECOM's client and may not be used, reproduced or relied upon by third parties, except as agreed by AECOM and its client, as required by law or for use by governmental reviewing agencies. AECOM accepts no responsibility, and denies any liability whatsoever, to any party that modifies this drawing without AECOM's express written consent. Do not scale this document. All measurements must be obtained from stated dimensions.

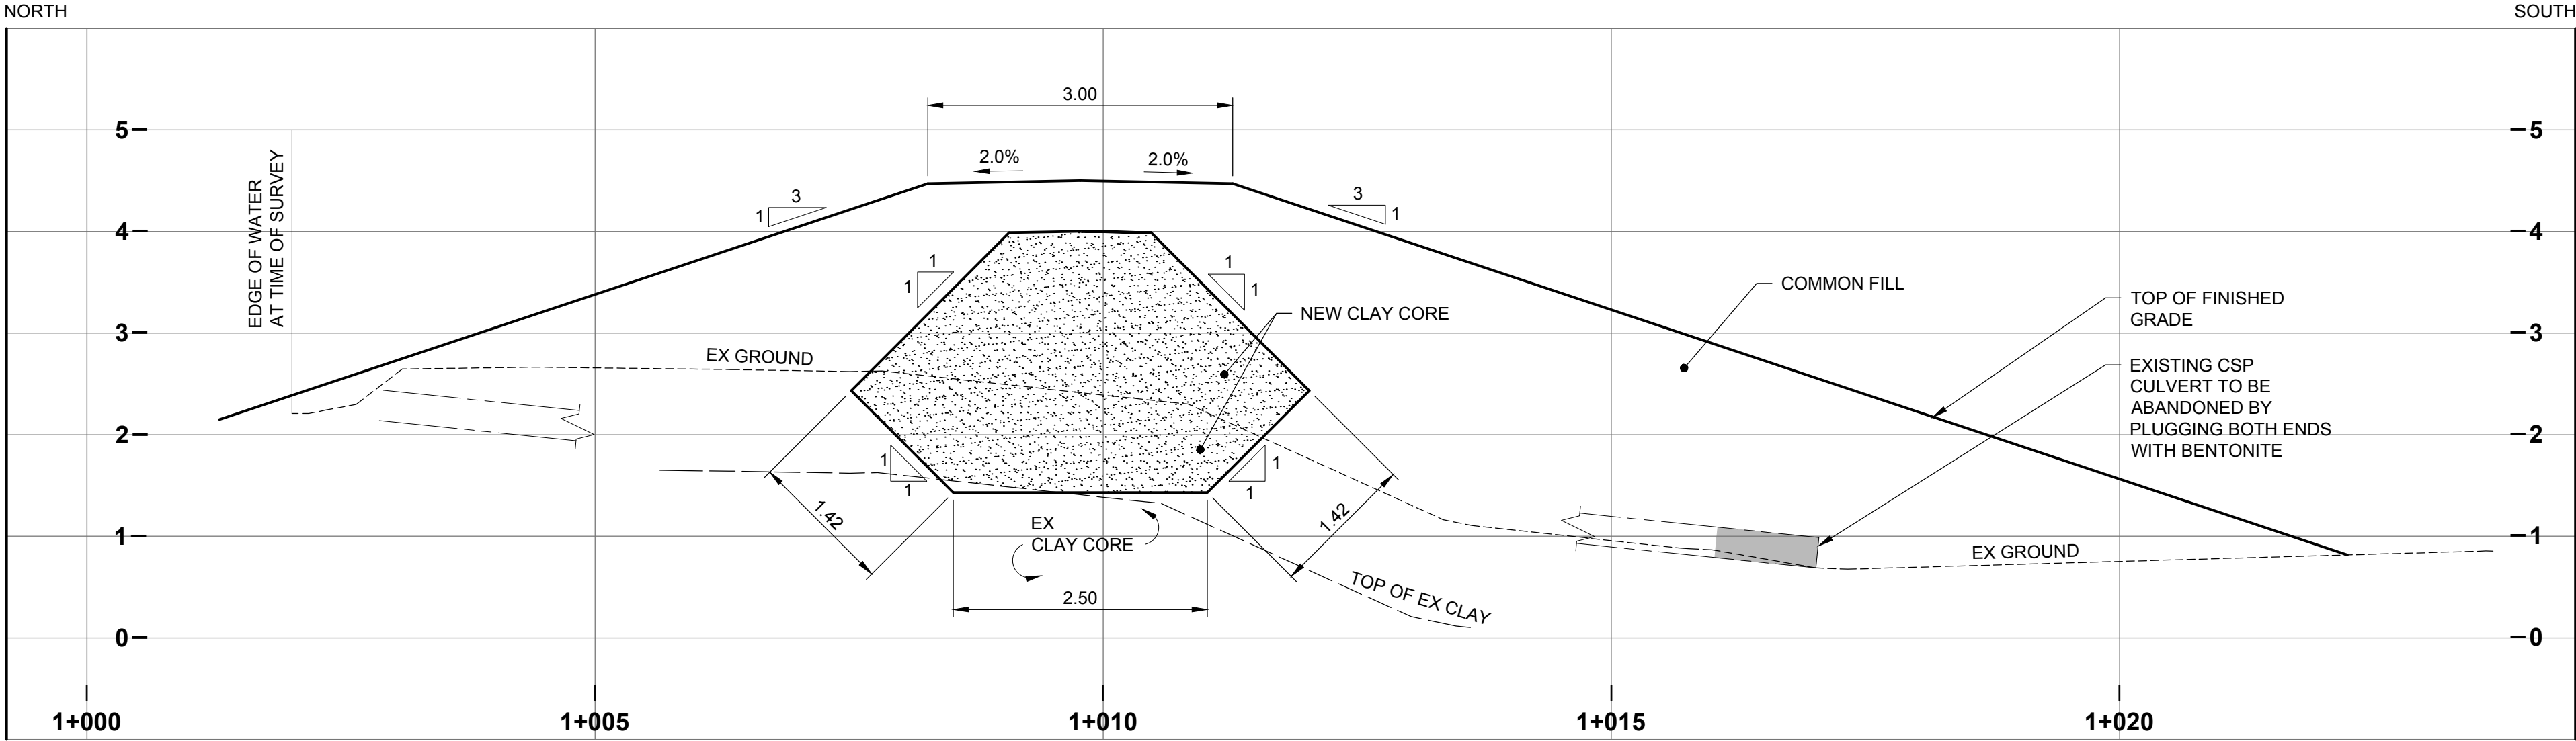

3 | SECTION
C-1100
0 1.25 2.5 m
1:50

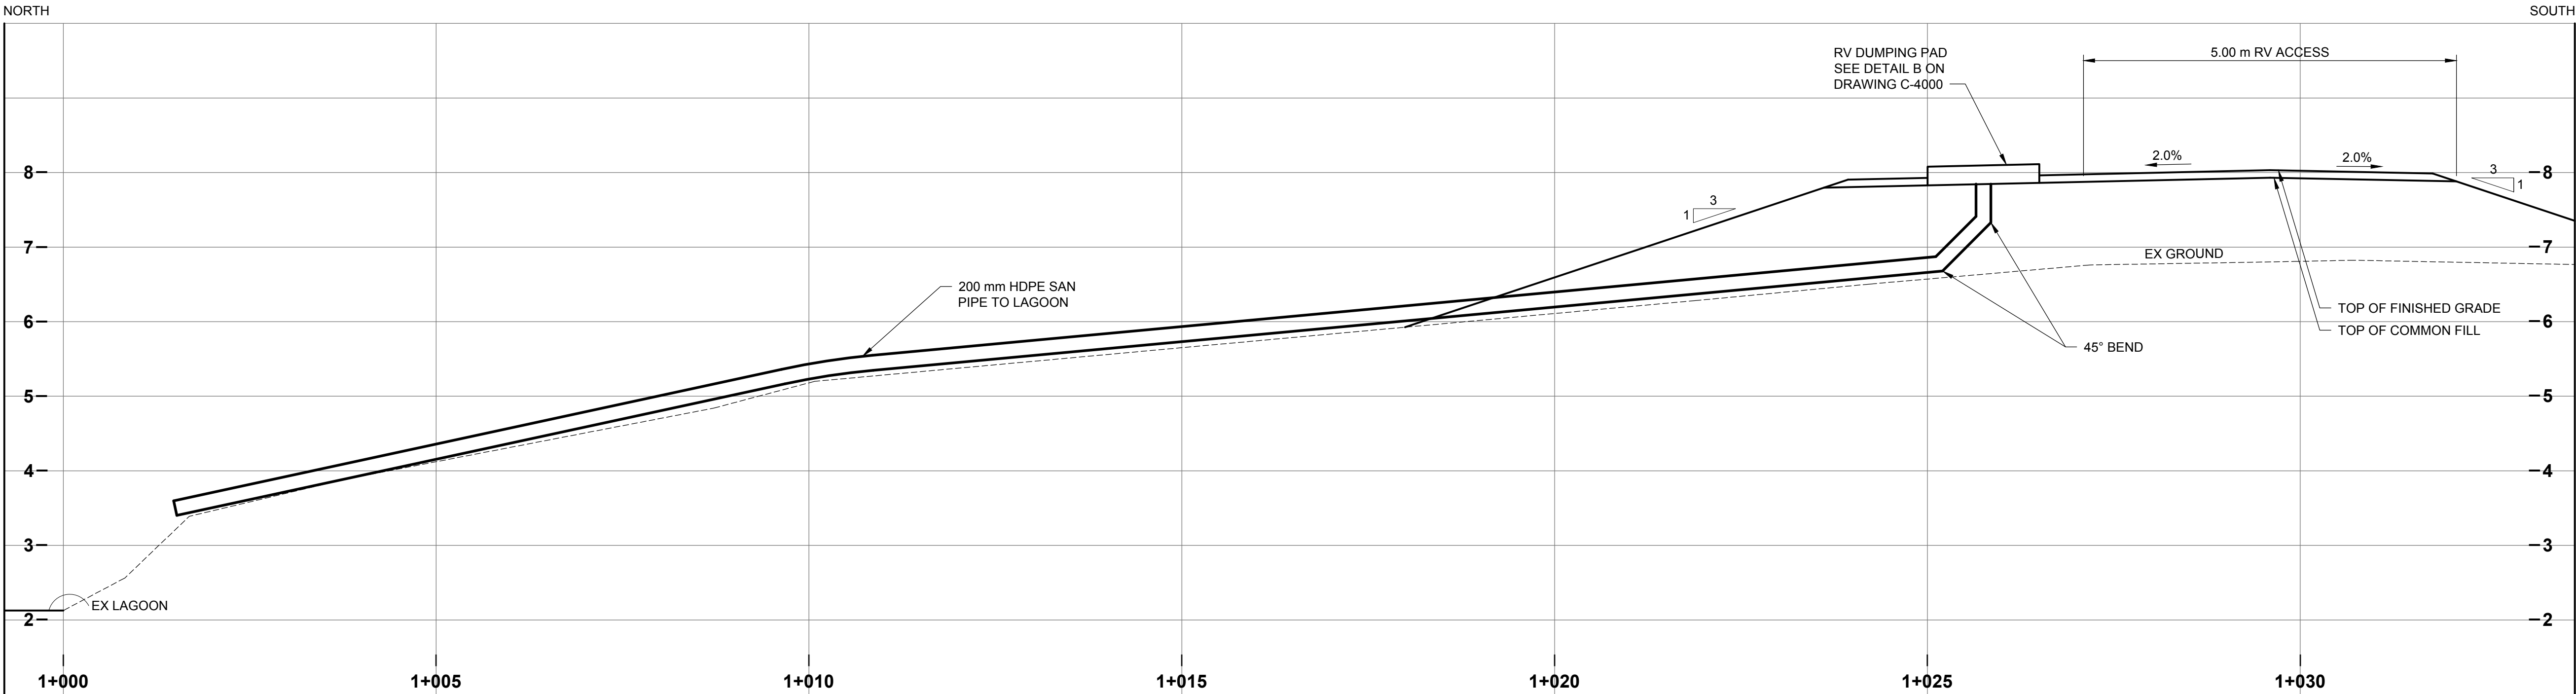

4 | SECTION
C-1001
0 1.25 2.5 m
1:50

GENERAL NOTES:

1. ALL DIMENSIONS AND ELEVATIONS ARE IN METRES UNLESS NOTED OTHERWISE.

AECOM

PROJECT

**TUKTOYAKTUK
SEWAGE LAGOON
UPGRADES**

CLIENT

**HAMLET OF
TUKTOYAKTUK**

CONSULTANT

AECOM
101, 18817 - STONY PLAIN ROAD NW
EDMONTON AB T5S 0C2
780.486.7000 tel 780.486.7070 fax
www.aecom.com

REGISTRATION

ISSUE/REVISION

I/R	DATE	DESCRIPTION
C	2017-01-24	INUVIALUIT WATER BOARD
B	2017-01-12	ISSUED FOR 95% REVIEW
A	2016-12-21	ISSUED FOR 80% REVIEW

KEY PLAN

PROJECT NUMBER

60519663


SHEET TITLE

SECTIONS
(SHEET 2 OF 2)


SHEET NUMBER

C-3001


This drawing has been prepared for the use of AECOM's client and may not be used, reproduced or relied upon by third parties, except as agreed by AECOM and its client, as required by law or for use by governmental reviewing agencies. AECOM accepts no responsibility, and denies any liability whatsoever, to any party that modifies this drawing without AECOM's express written consent. Do not scale this document. All measurements must be obtained from stated dimensions.

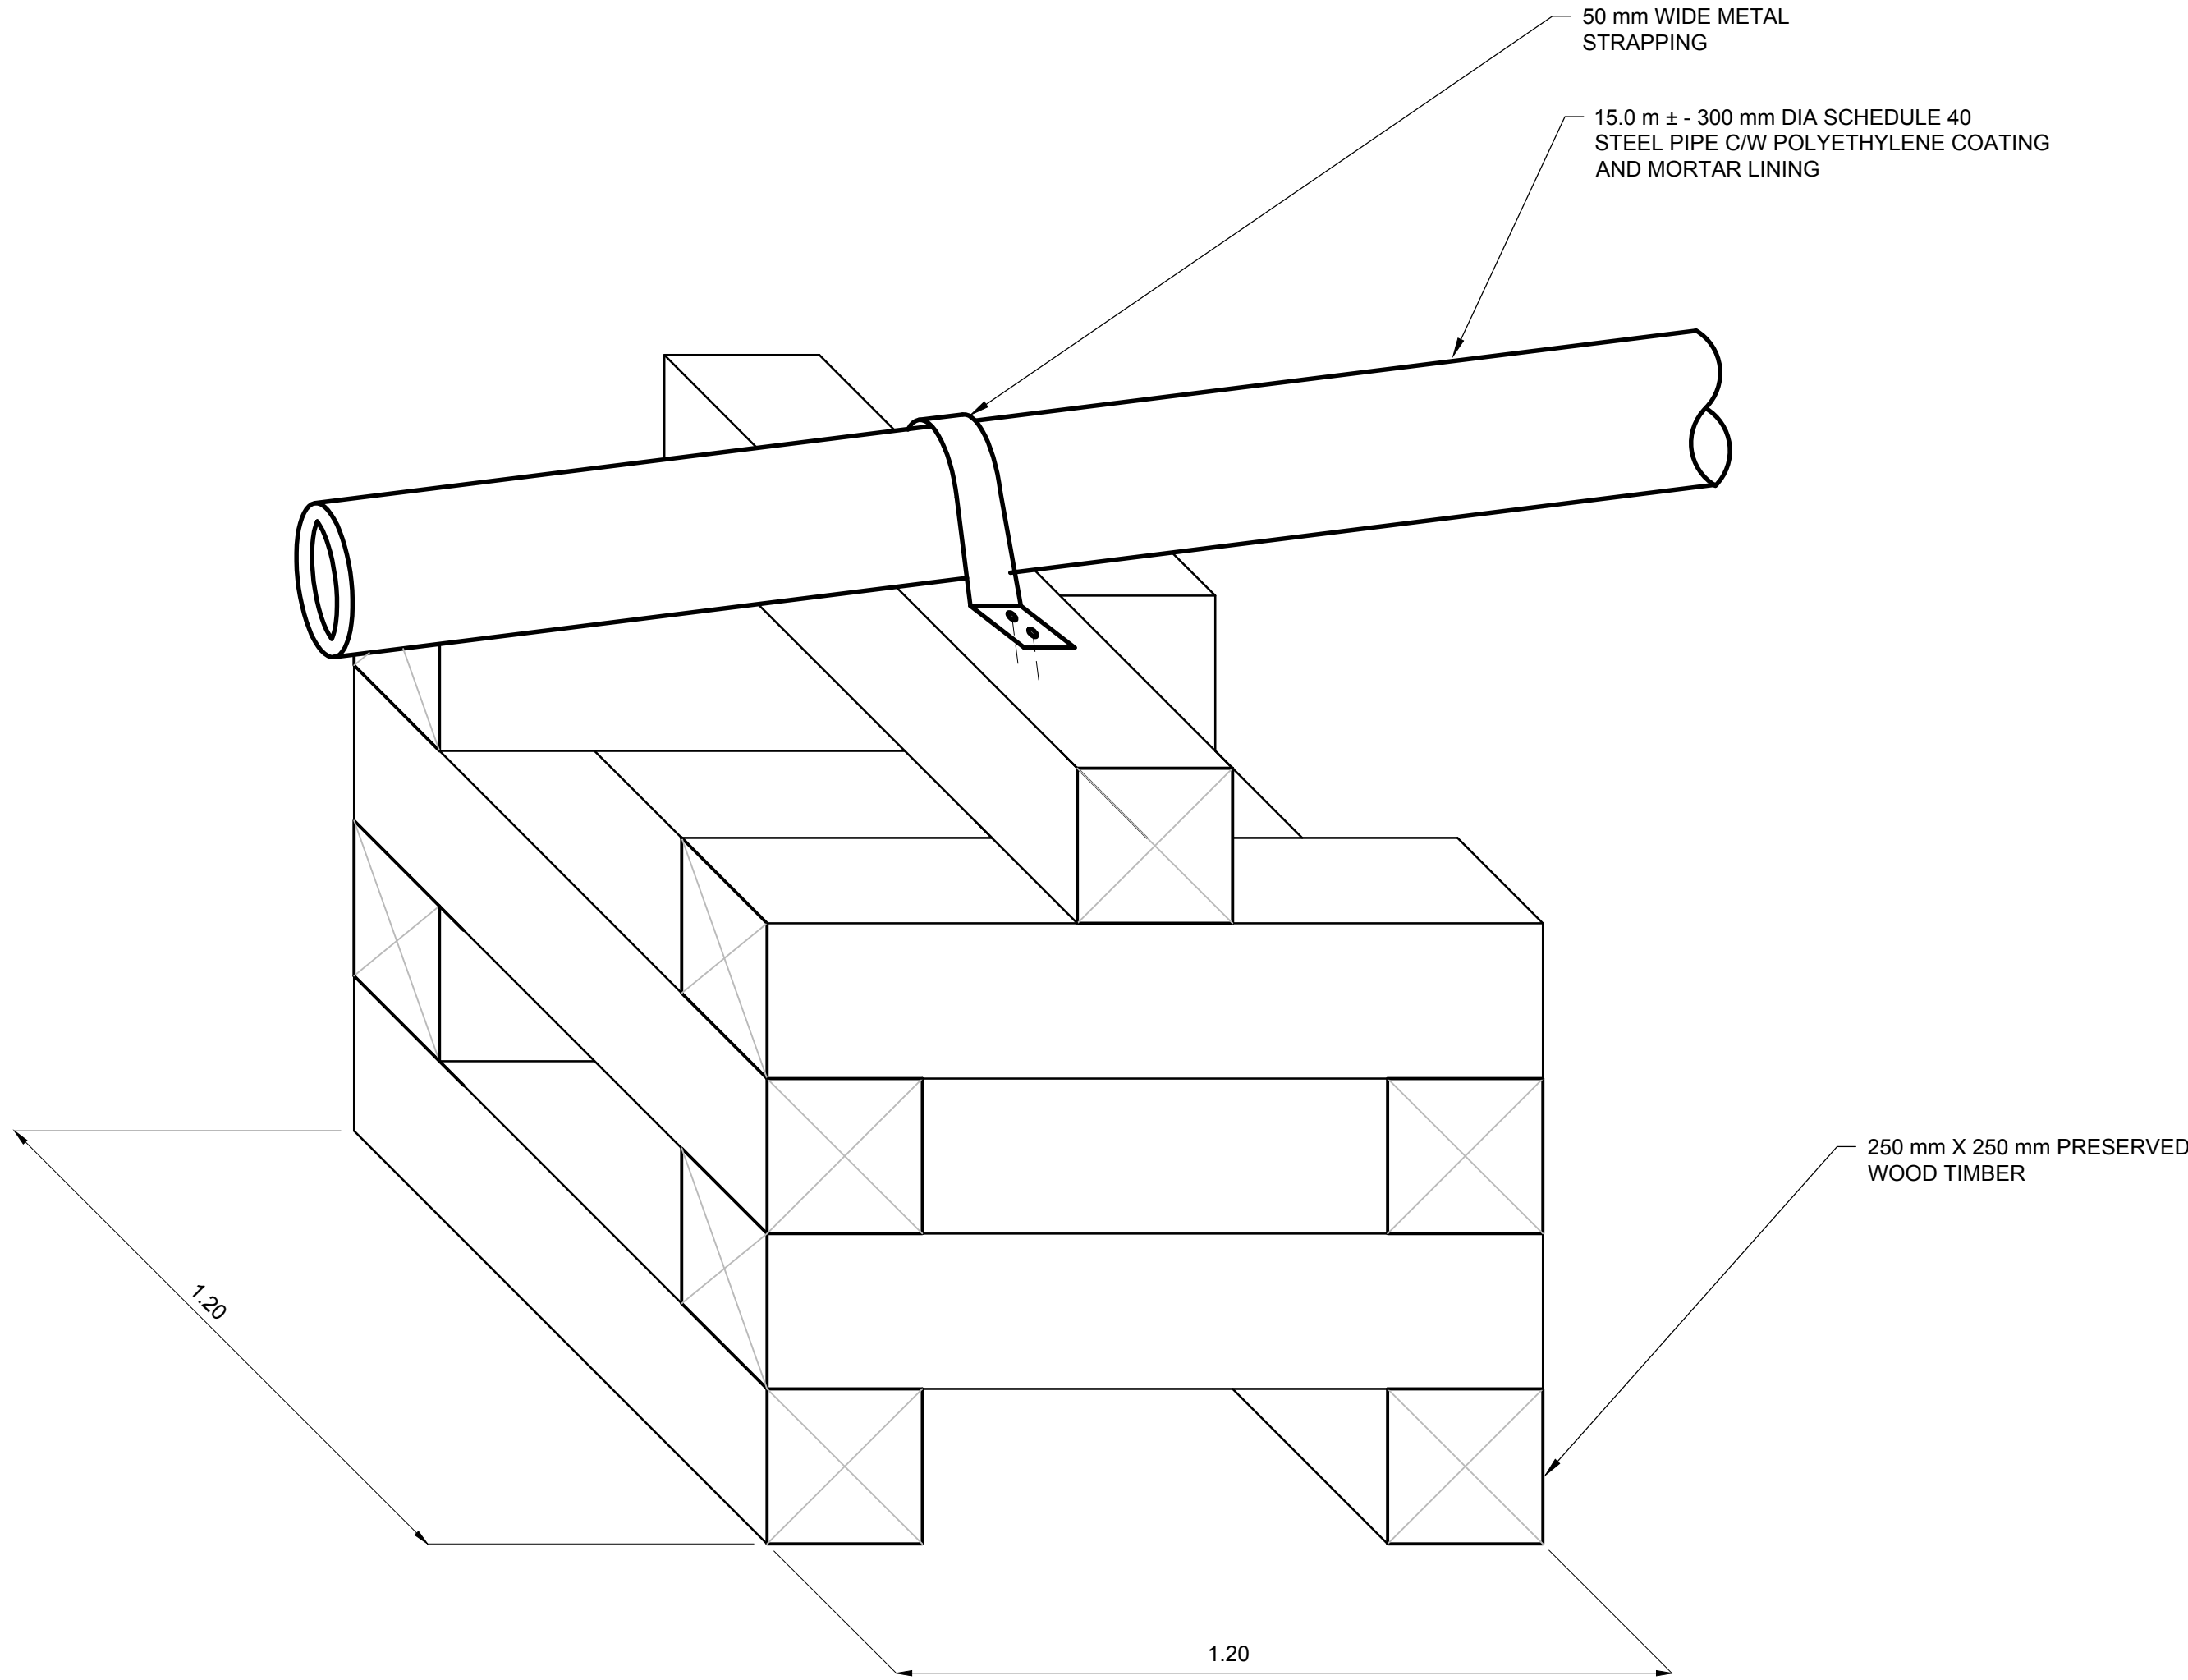


A | WOOD CRIBBING DETAIL
C-3000 SCALE 1:10

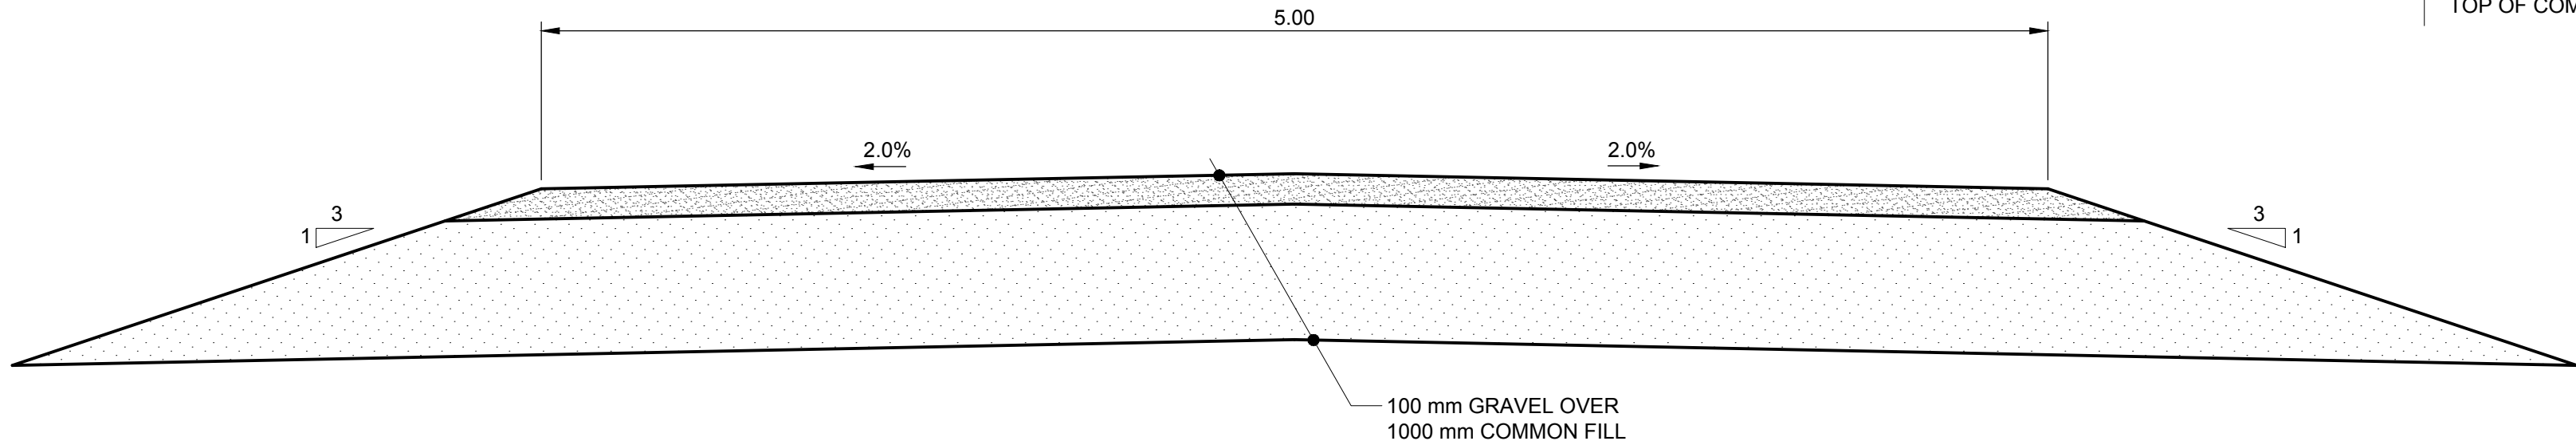

5 | ROAD SECTION
C-1101 Scale 1:20

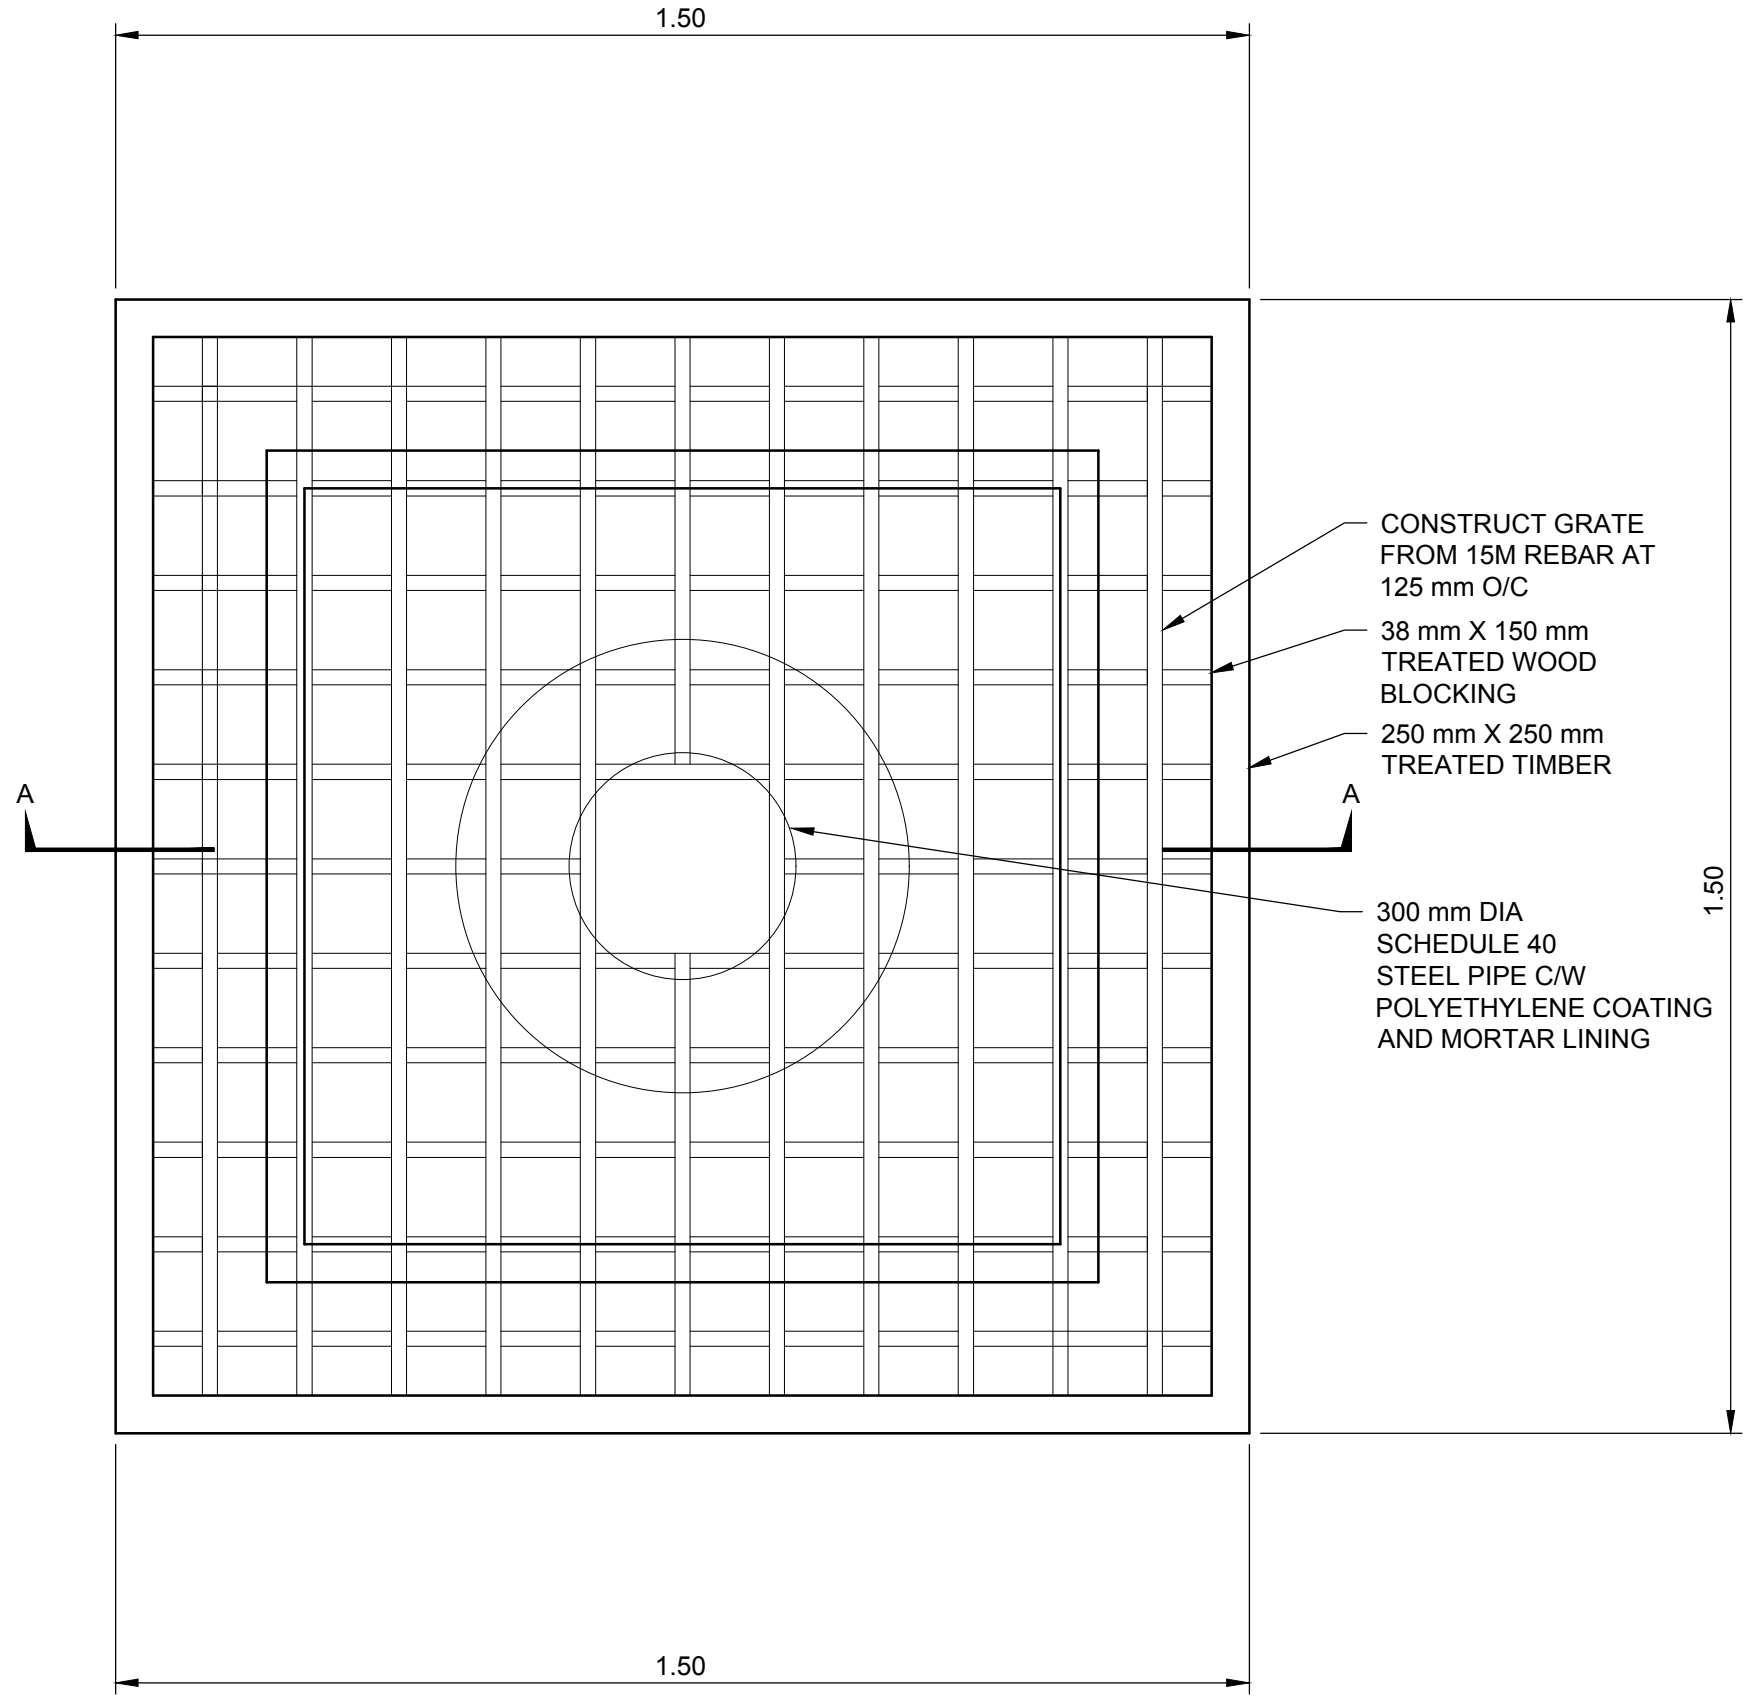

PLAN

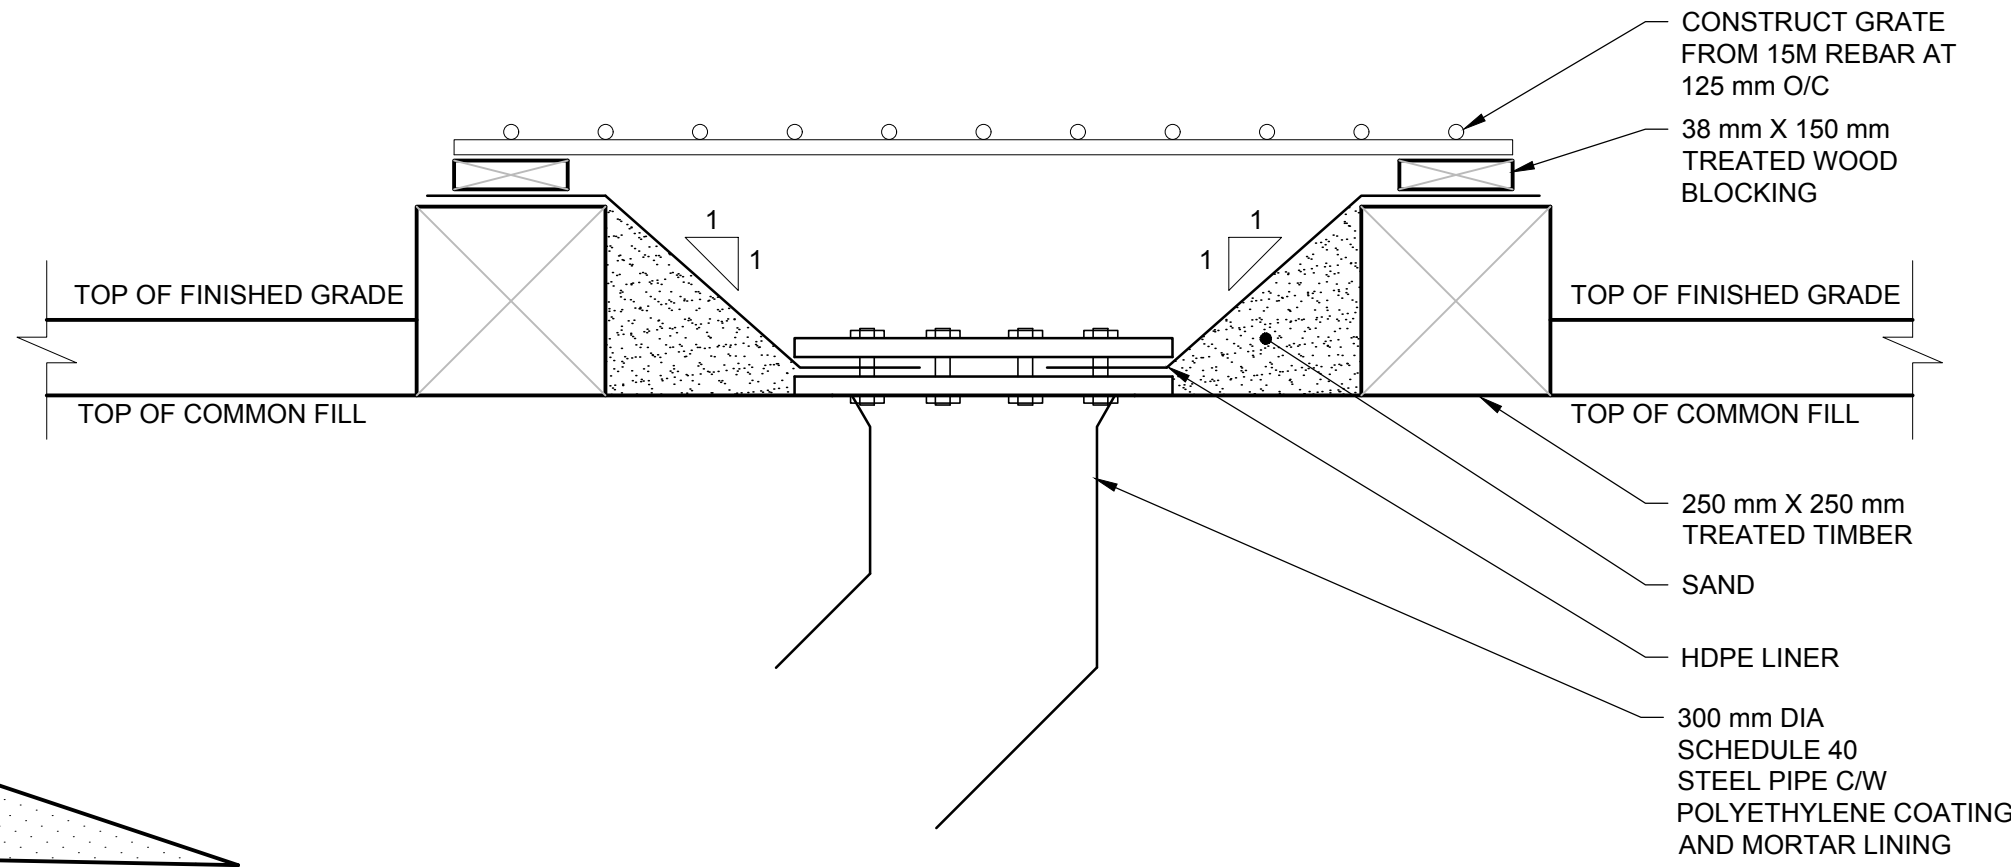

SECTION "A-A"

B | RV DUMPING PAD
SCALE 1:10

GENERAL NOTES:

1. ALL DIMENSIONS AND ELEVATIONS ARE IN METRES UNLESS NOTED OTHERWISE.

AECOM

PROJECT

**TUKTOYAKTUK
SEWAGE LAGOON
UPGRADES**

CLIENT

**HAMLET OF
TUKTOYAKTUK**

CONSULTANT

AECOM
101, 18817 - STONY PLAIN ROAD NW
EDMONTON AB T5S 0C2
780.486.7000 tel 780.486.7070 fax
www.aecom.com

REGISTRATION

ISSUE/REVISION

I/R	DATE	DESCRIPTION
C	2017-01-24	INUUVIUIT WATER BOARD
B	2017-01-12	ISSUED FOR 95% REVIEW
A	2016-12-21	ISSUED FOR 80% REVIEW

KEY PLAN

PROJECT NUMBER

60519663

SHEET TITLE

DETAILS

SHEET NUMBER

C-4000

This drawing has been prepared for the use of AECOM's client and may not be used, reproduced or relied upon by third parties, except as agreed by AECOM and its client, as required by law or for use by governmental reviewing agencies. AECOM accepts no responsibility, and denies any liability whatsoever to any party that modifies this drawing without AECOM's express written consent. Do not scale this document. All measurements must be obtained from stated dimensions.